






TABLE OF CONTENTS	
Sheet Number	Sheet Name
A-00	COVER PAGE
A-01	FLOOR PLAN LEVEL 1
A-02	FLOOR PLAN LEVEL 2
A-03	FLOOR PLAN LEVEL 3
A-04	ROOF PLAN
A-11	FRONT ELEVATION
A-12	RIGHT-SIDE ELEVATION
A-13	REAR ELEVATION
A-14	LEFT-SIDE ELEVATION
A-21	LONGITUDINAL SECTIONAL VIEW
A-22	CROSS SECTIONAL VIEW
A-31	REF. CEILING PLAN LEVEL 1
A-32	REF. CEILING PLAN LEVEL 2
A-33	REF. CEILING PLAN LEVEL 3
A-40	DOORS AND WINDOWS SCHEDULE
A-50	SPOT DETAILS
A-51	SPOT DETAILS
A-60	TOILET SPOT DETAILS
A-61	TOILET SPOT FLOOR PLANS

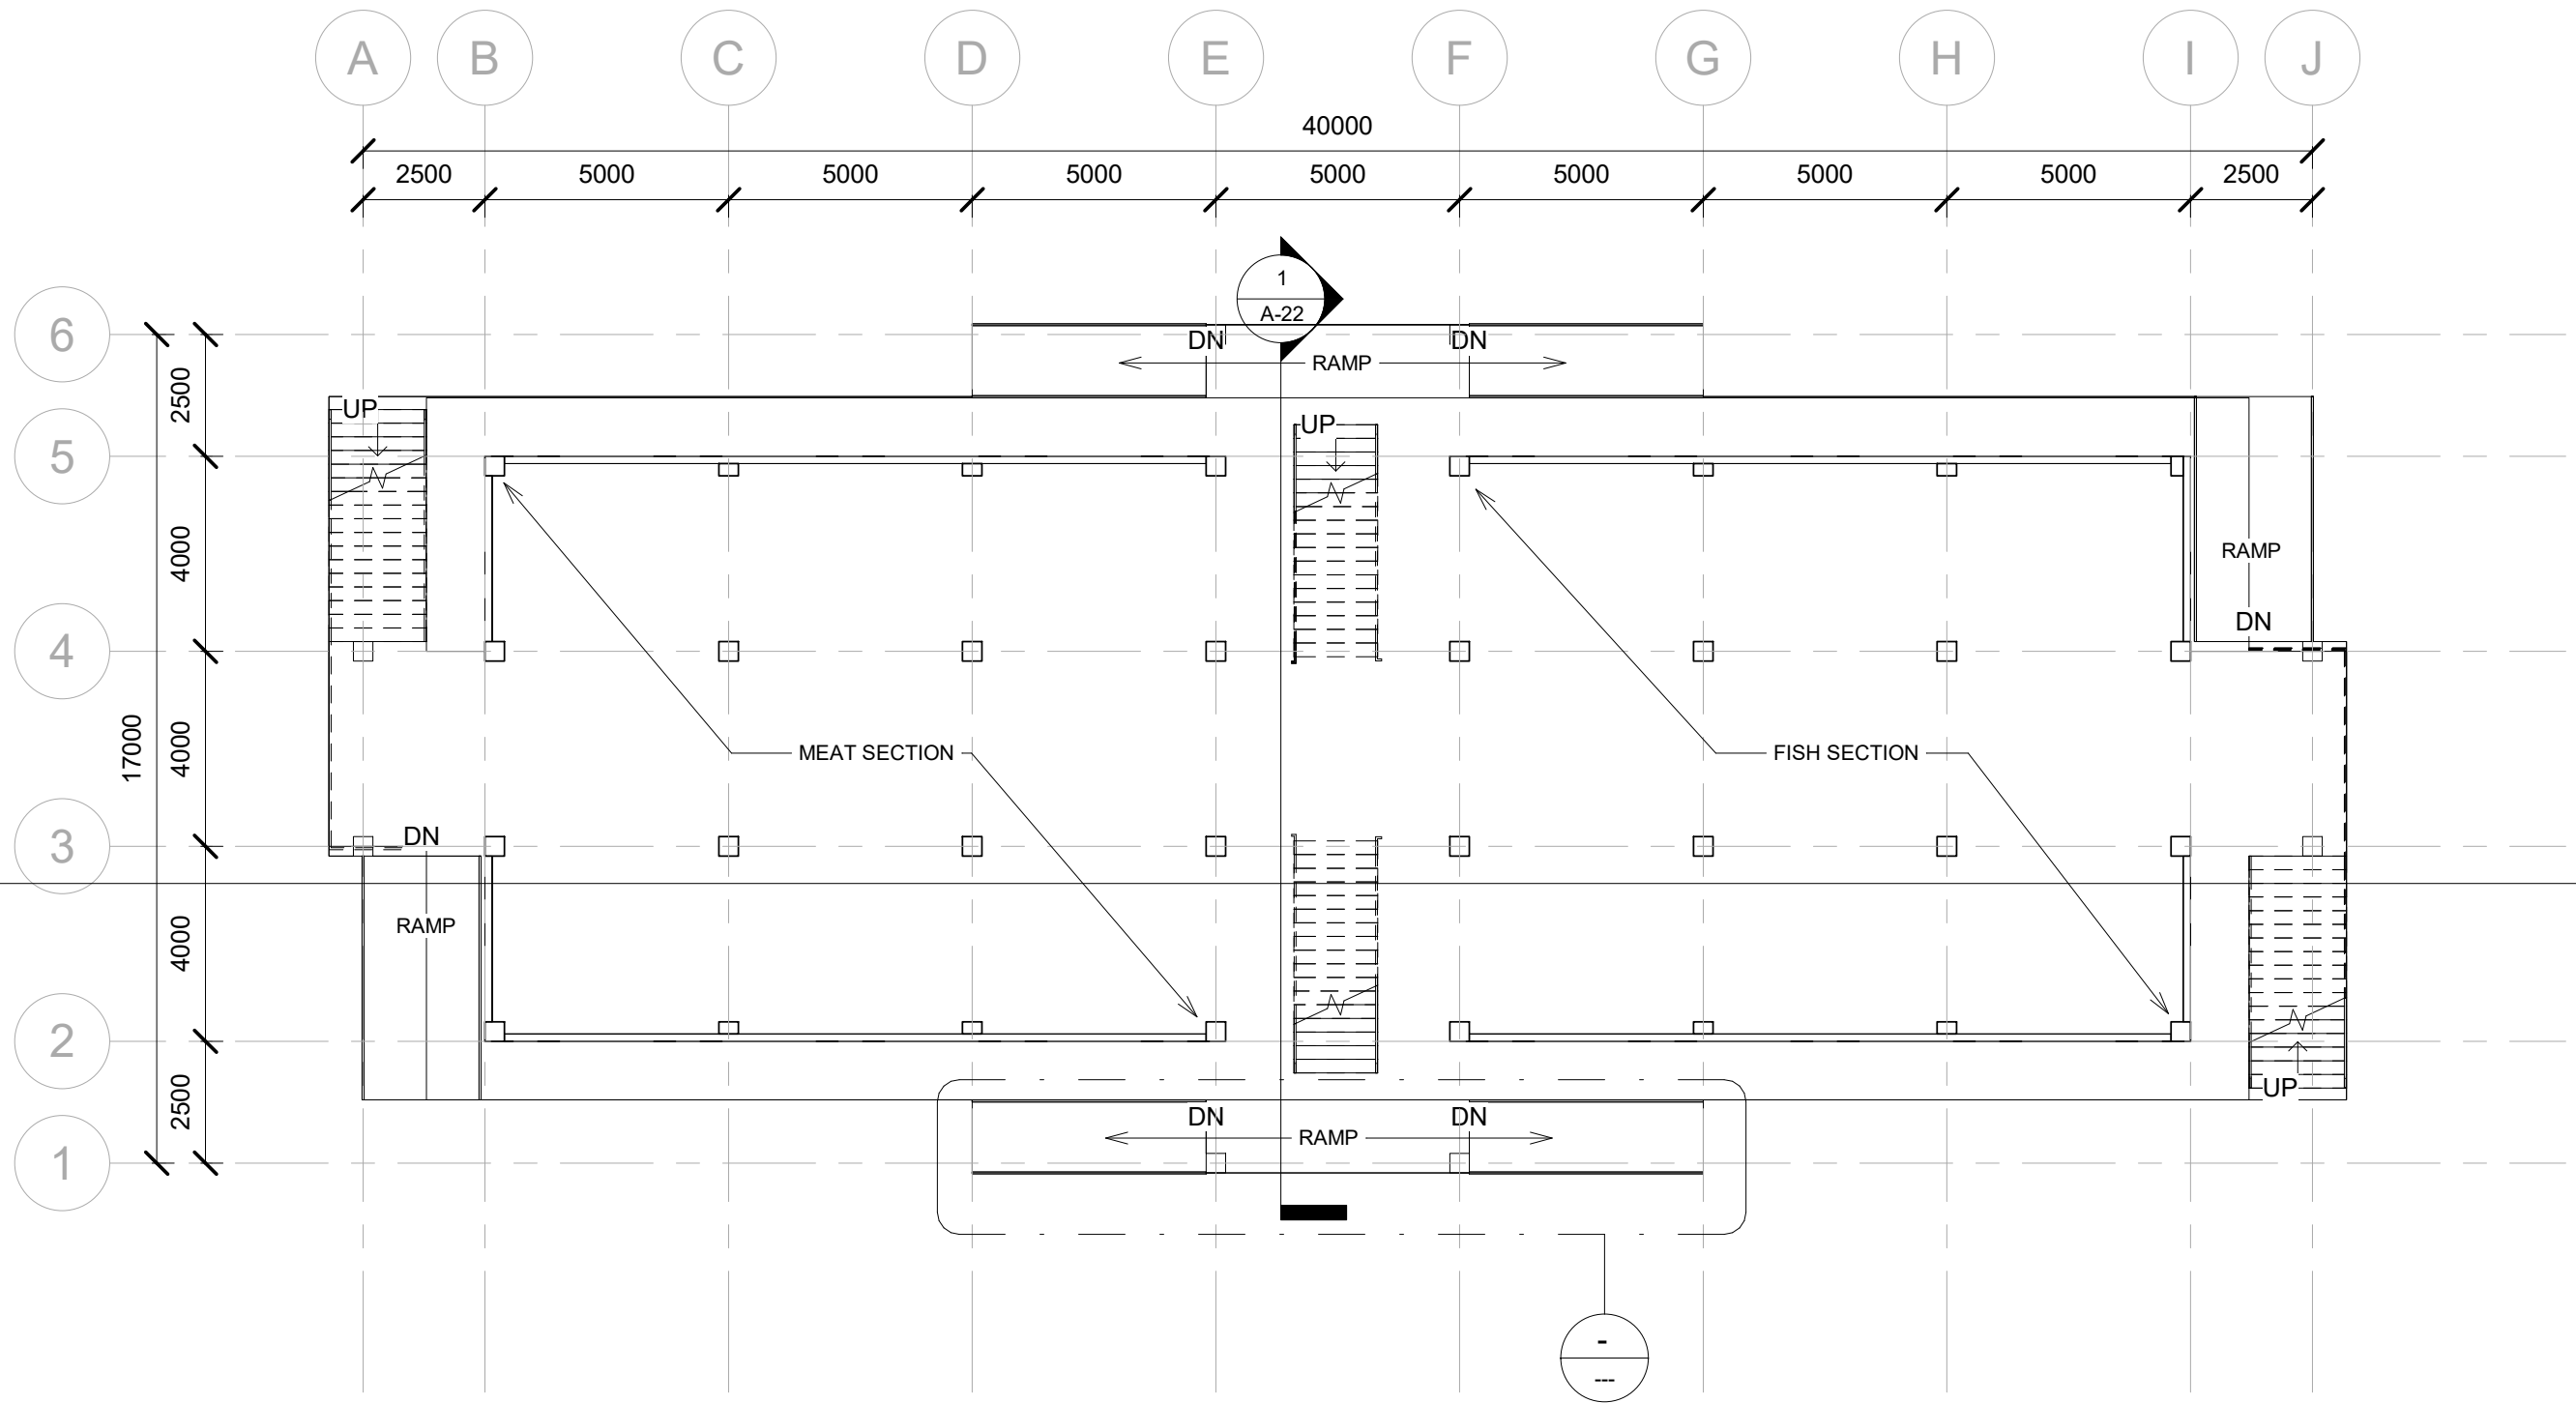


1 LEVEL 1
1 : 150

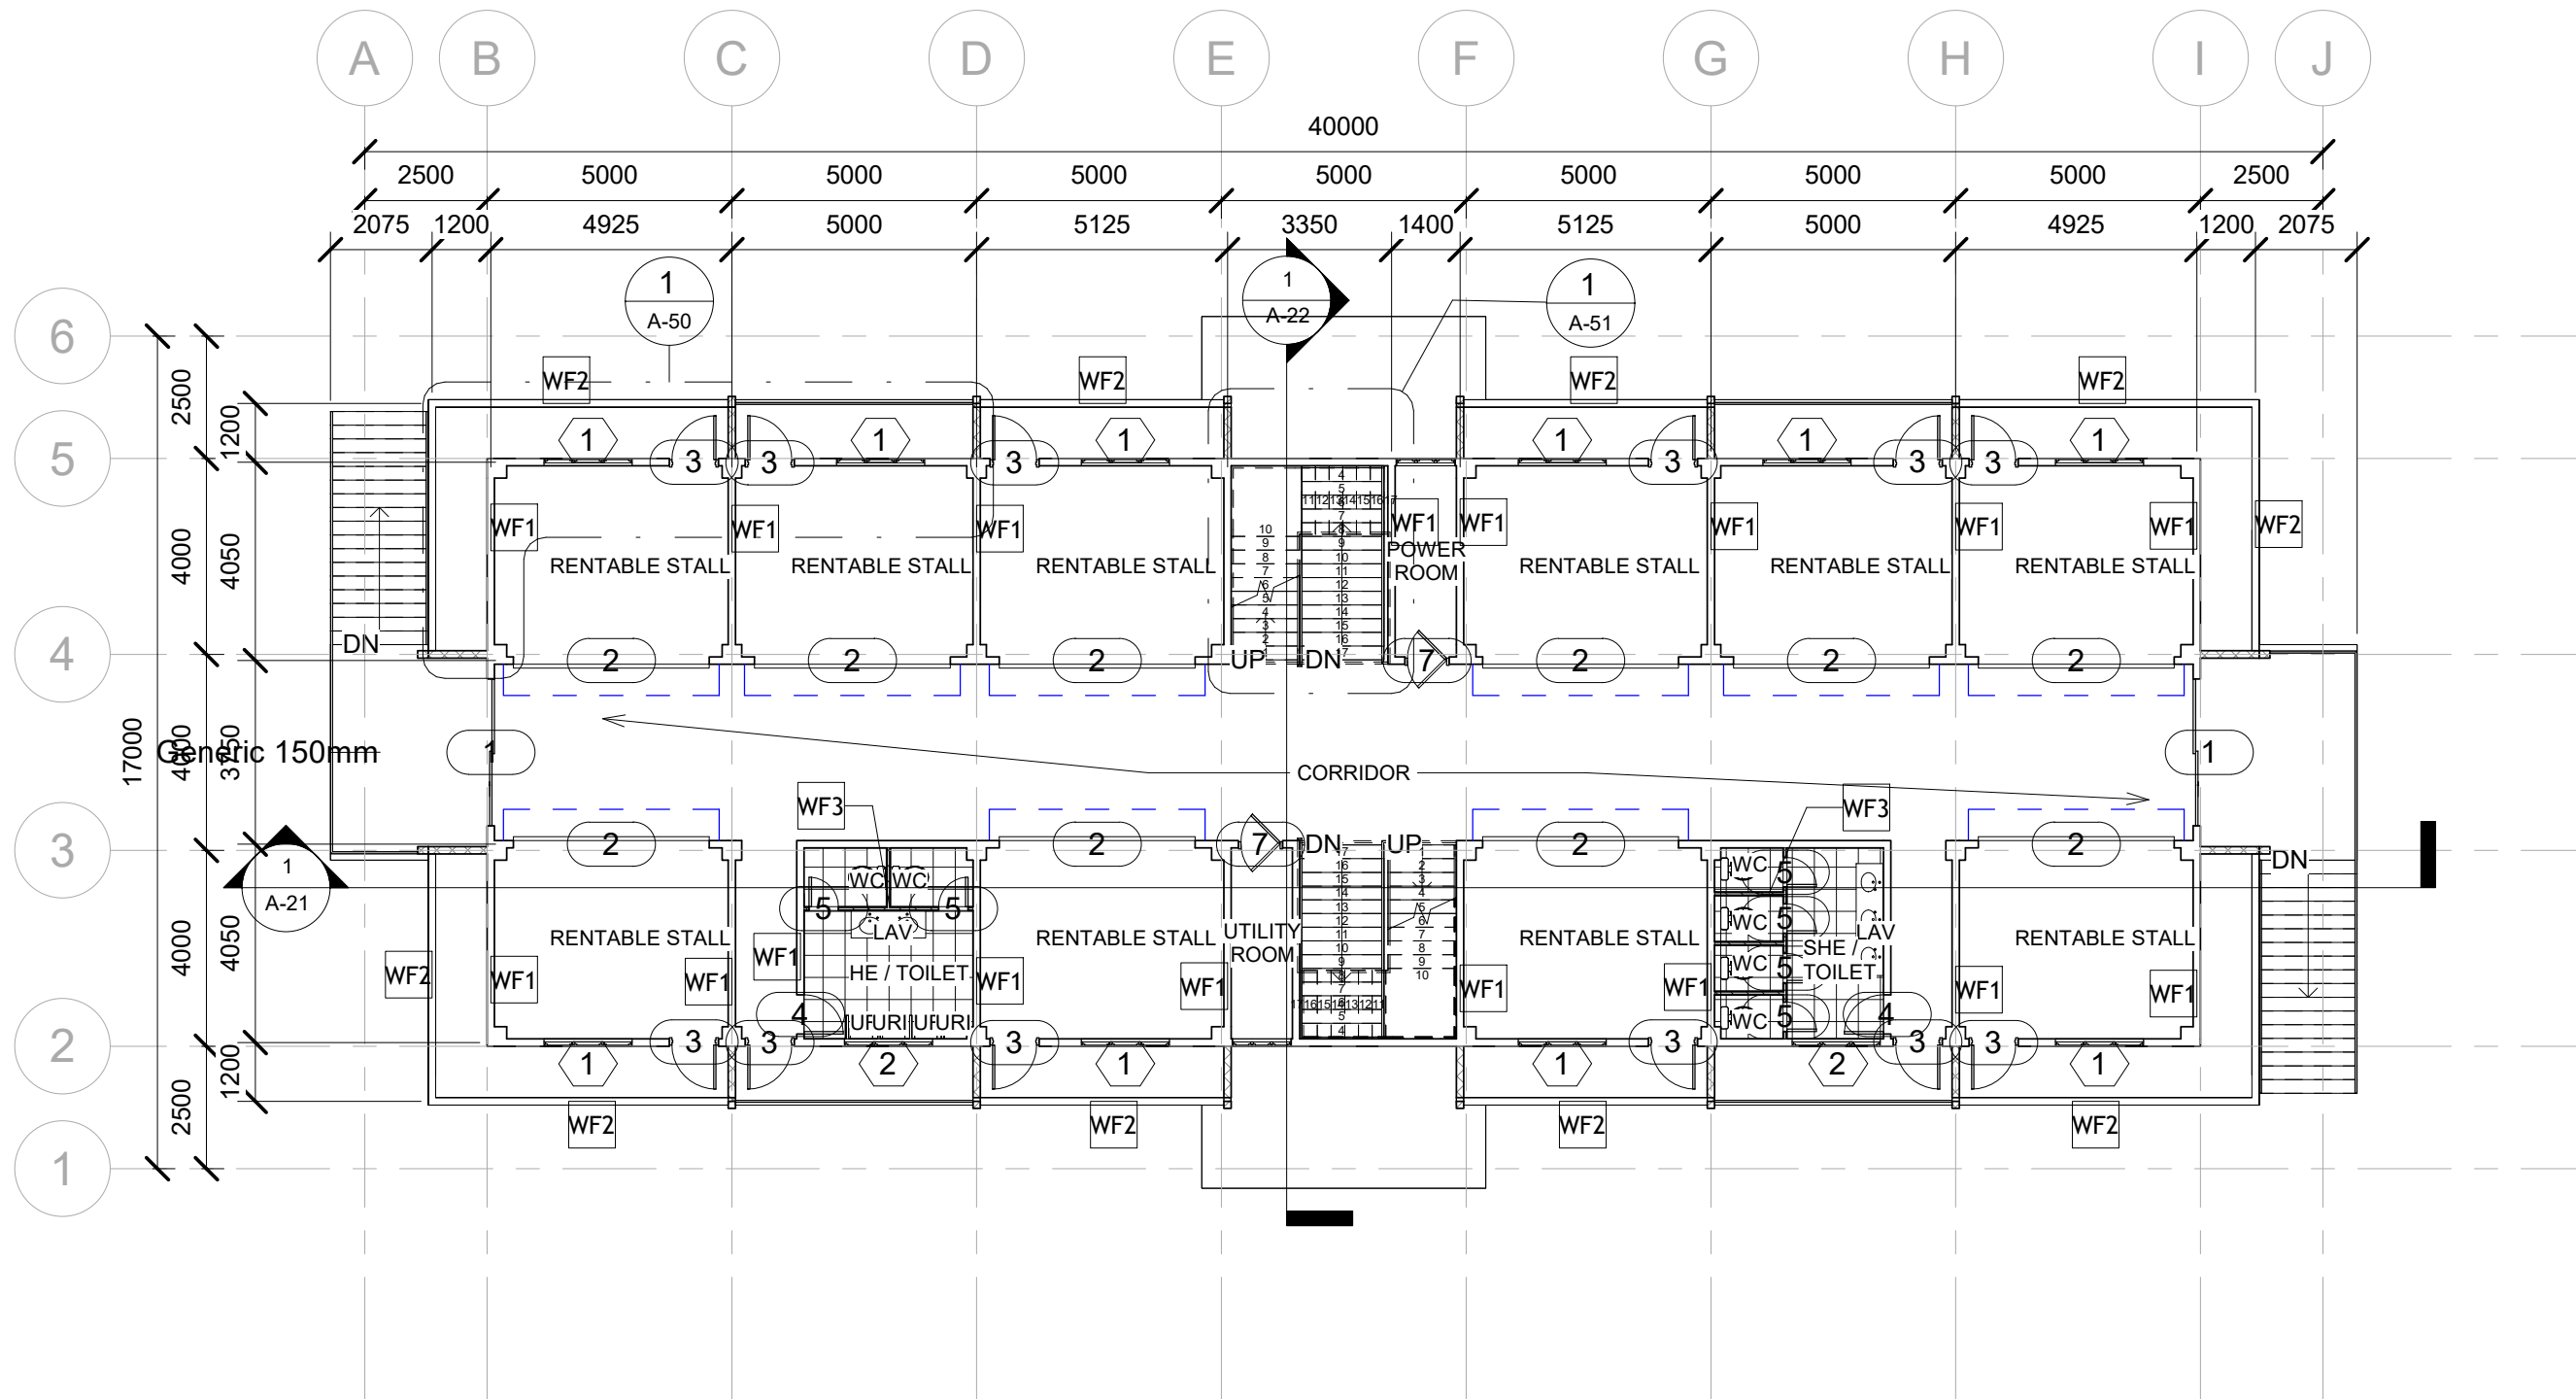

1 LEVEL 2
1 : 150

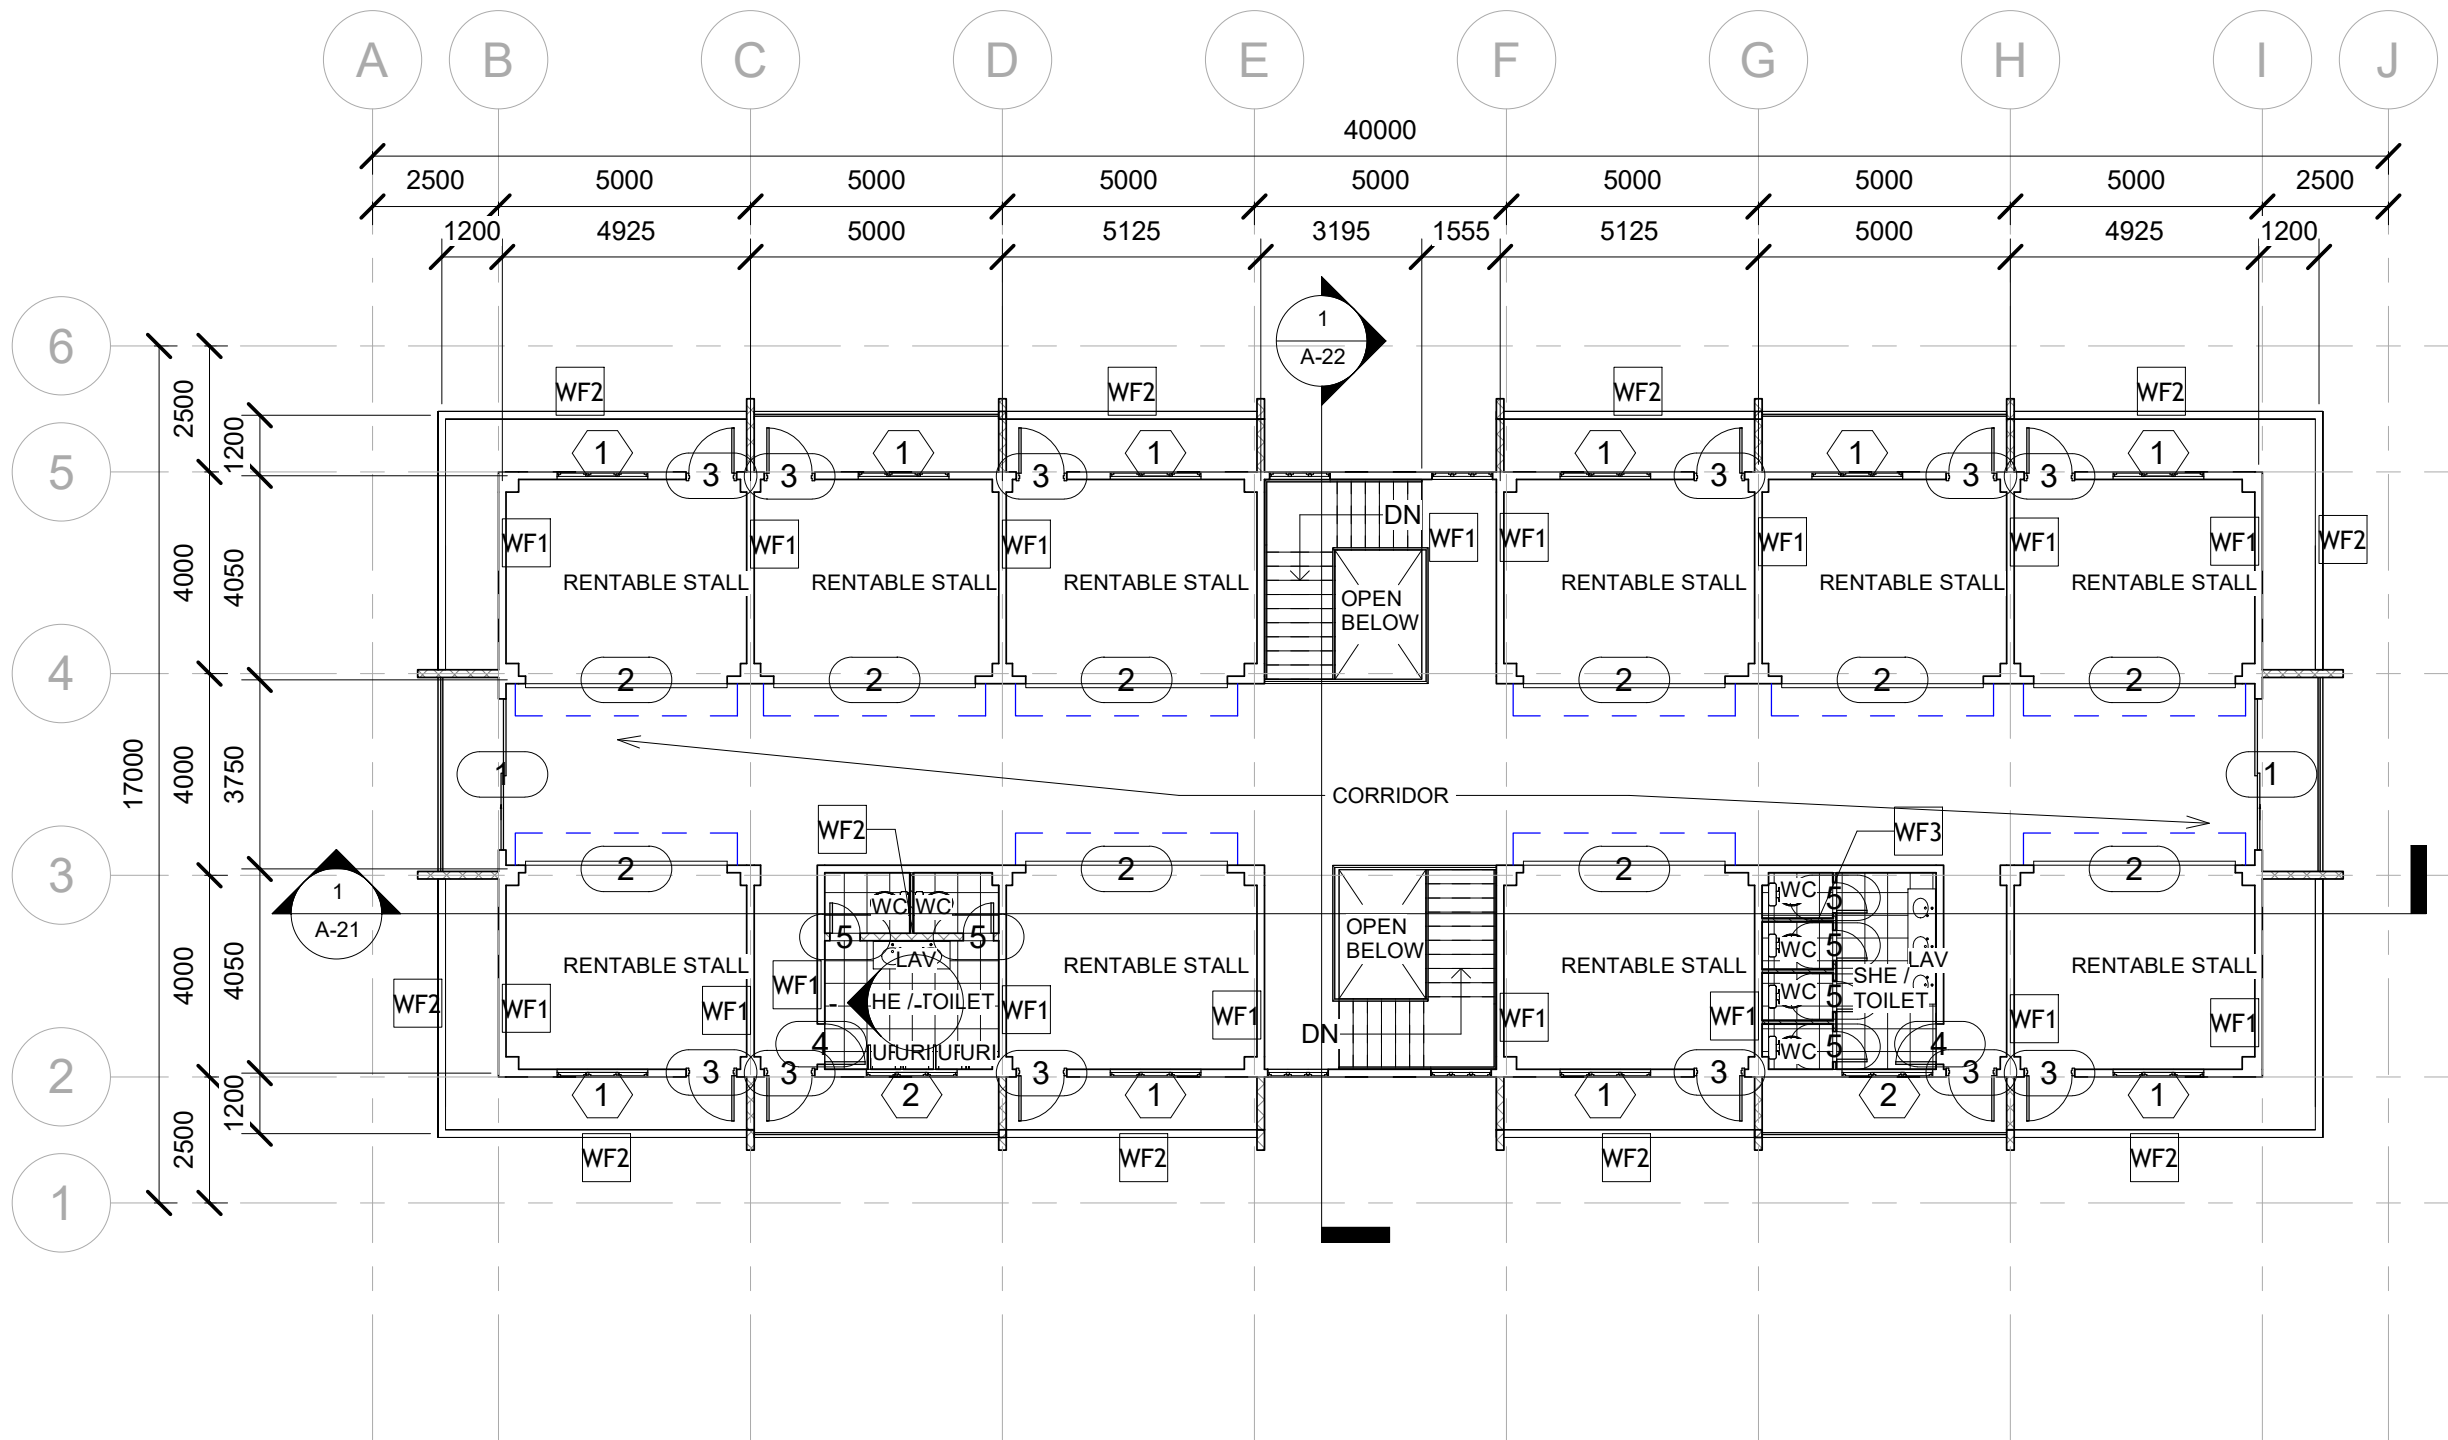

1 LEVEL 3
1 : 150

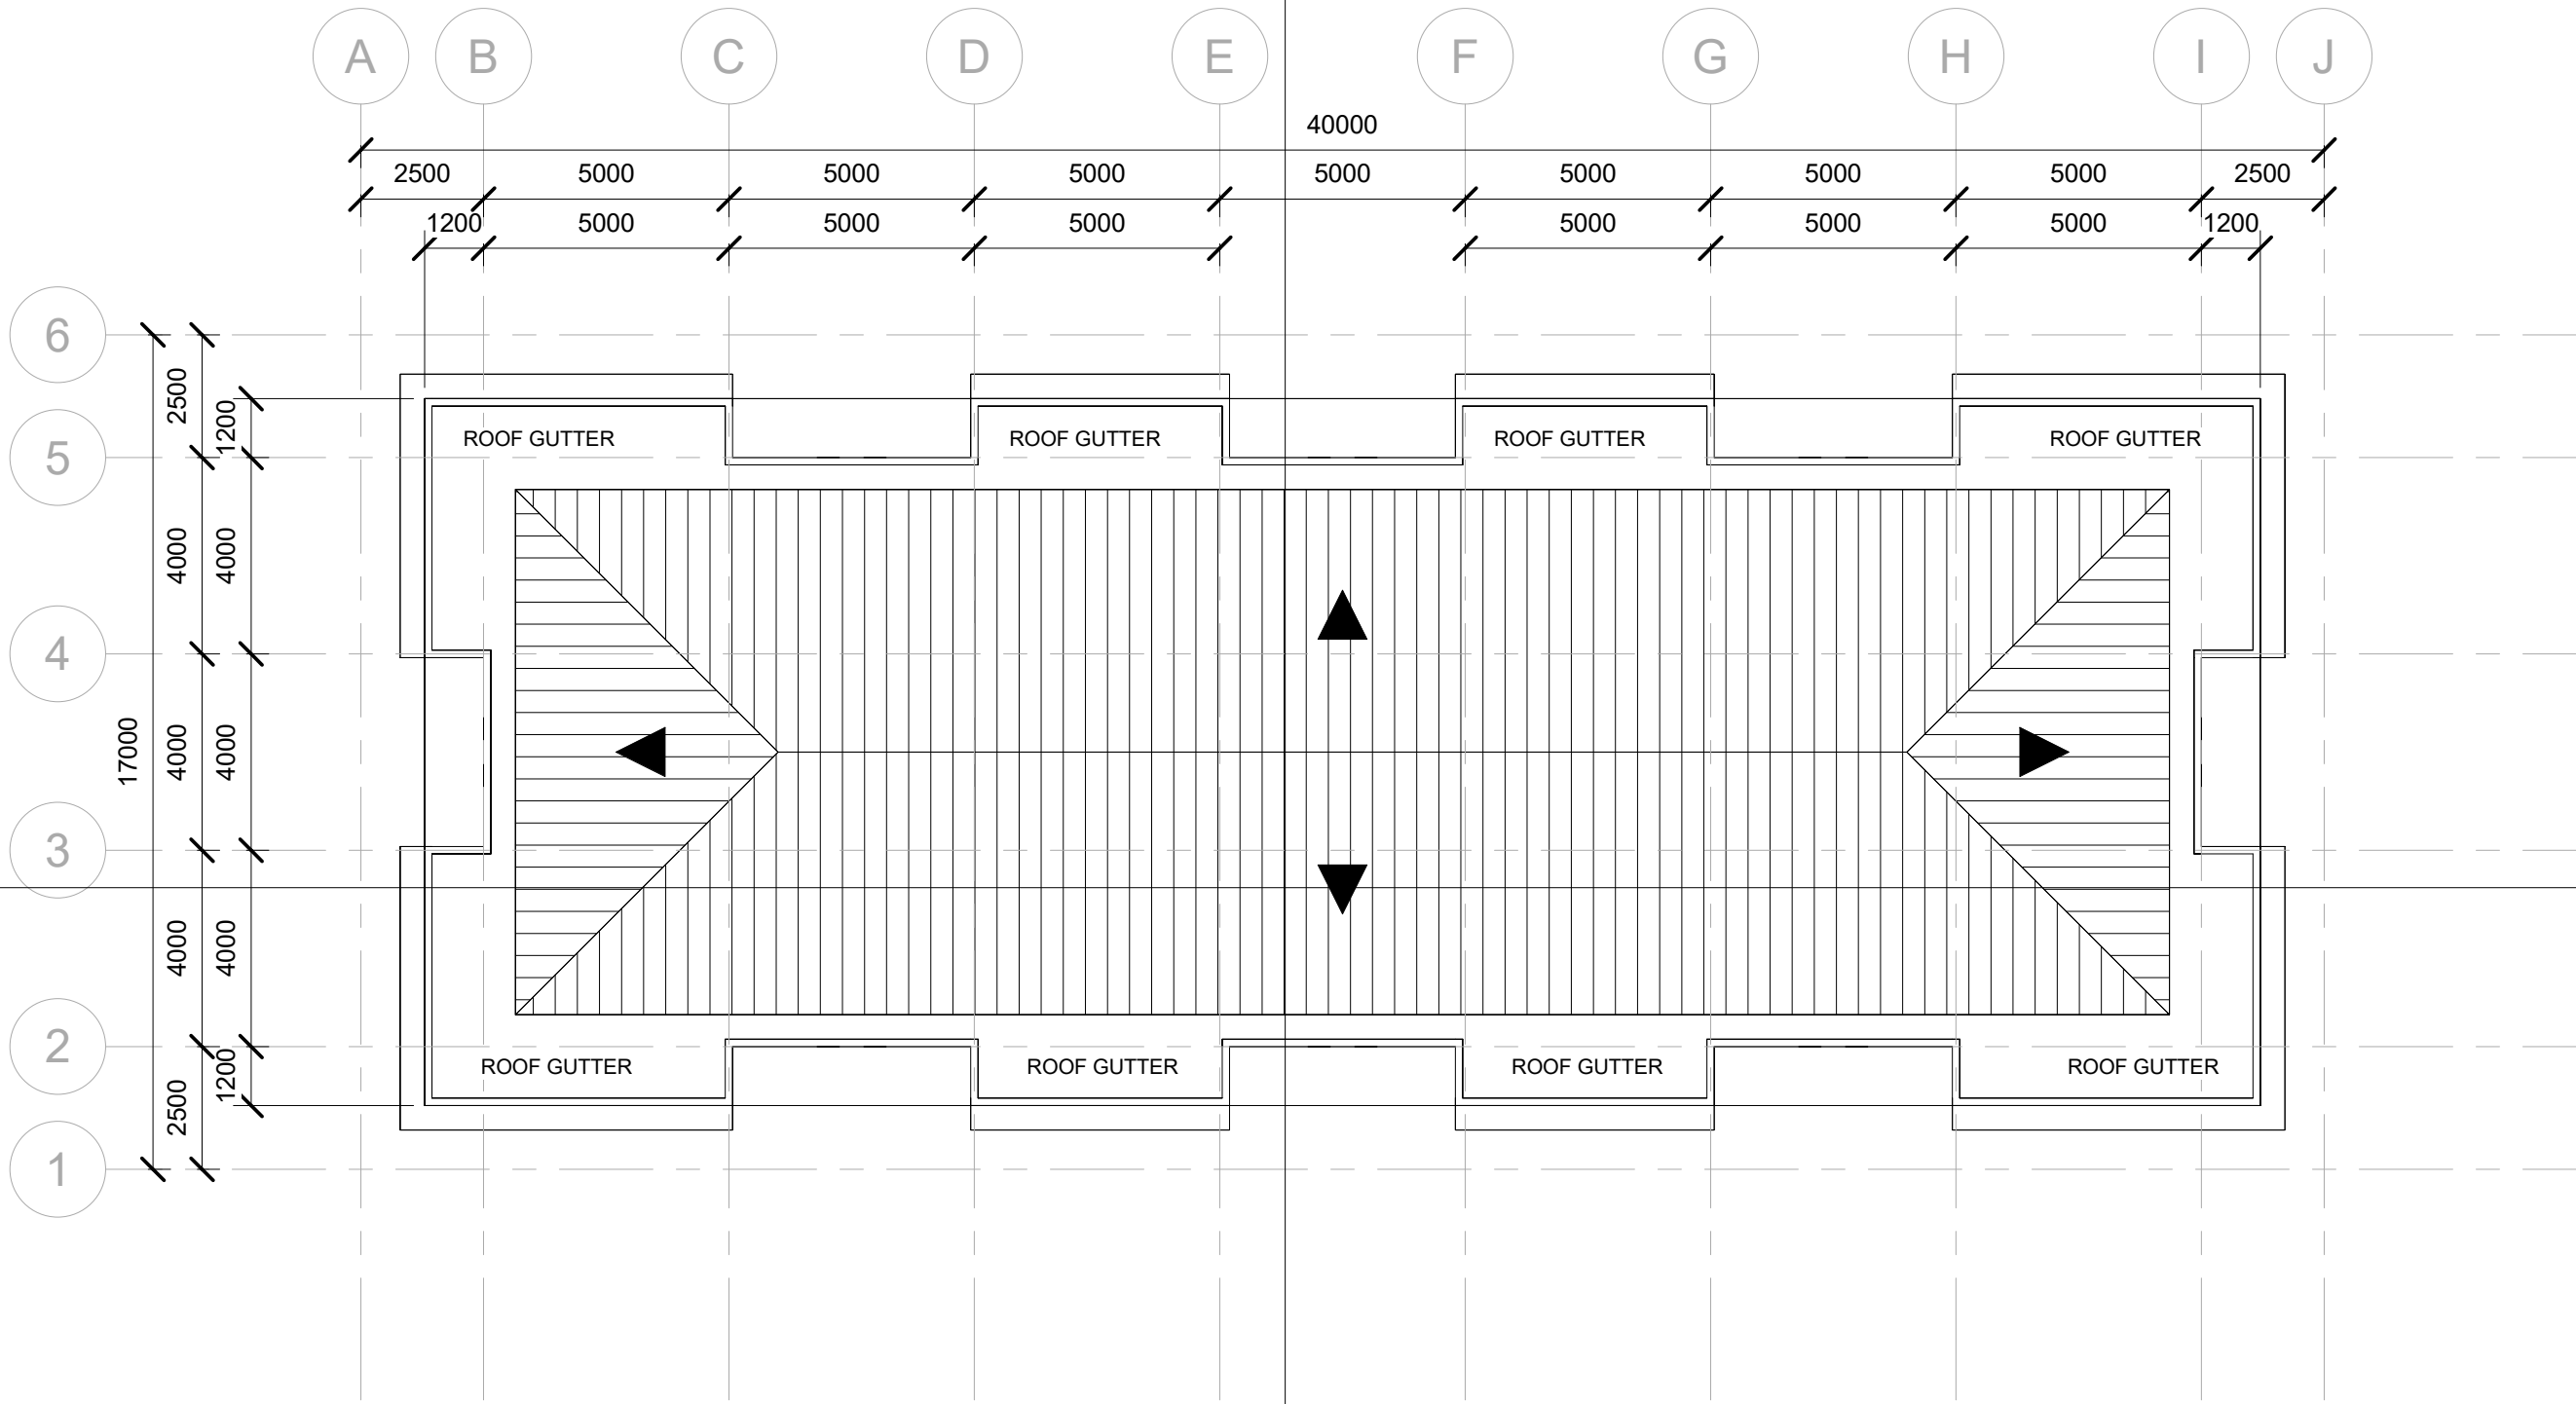

1 ROOF
1 : 150


WF2 - WOODEN FLUTINGS PAINTED PANEL FINISHES
(REFER TO MATERIAL SPECIFICATIONS)
CONSTRUCTED AT 1000mm HEIGHT SERVES
AS ROOF GUARD EPOXY-BASED PAINTS APPLIED.

EXTENDED CANOPIES FOR SUN SHADING.
NOTE: THAT ALL CANOPIES AND FLOOR EXTENSION
SHOULD HAVE GROOVES TO MINIMIZE RAIN
WATER GOING TO THE WALL AND FLOOR
TERMINATIONS

900mm METAL RAILING FULLY WELDED PIPE ON
CONCRETE STAIRS. PAINTED WITH EPOXY
PRIMER TO PREVENT RUST AND CORROSION.

EXTRUDED ALUMINUM FRAMING
AND GLASS STOREFRONT SLIDING
DOOR (SEE DOOR SCHEDULE)

1:12 SLOPE RATIO FOR RAMPS
PROVIDED WITH 900mm METAL
RAILING FULLY WELDED PIPE. PAINTED
WITH EPOXY PRIMER TO PREVENT
RUST AND CORROSION.

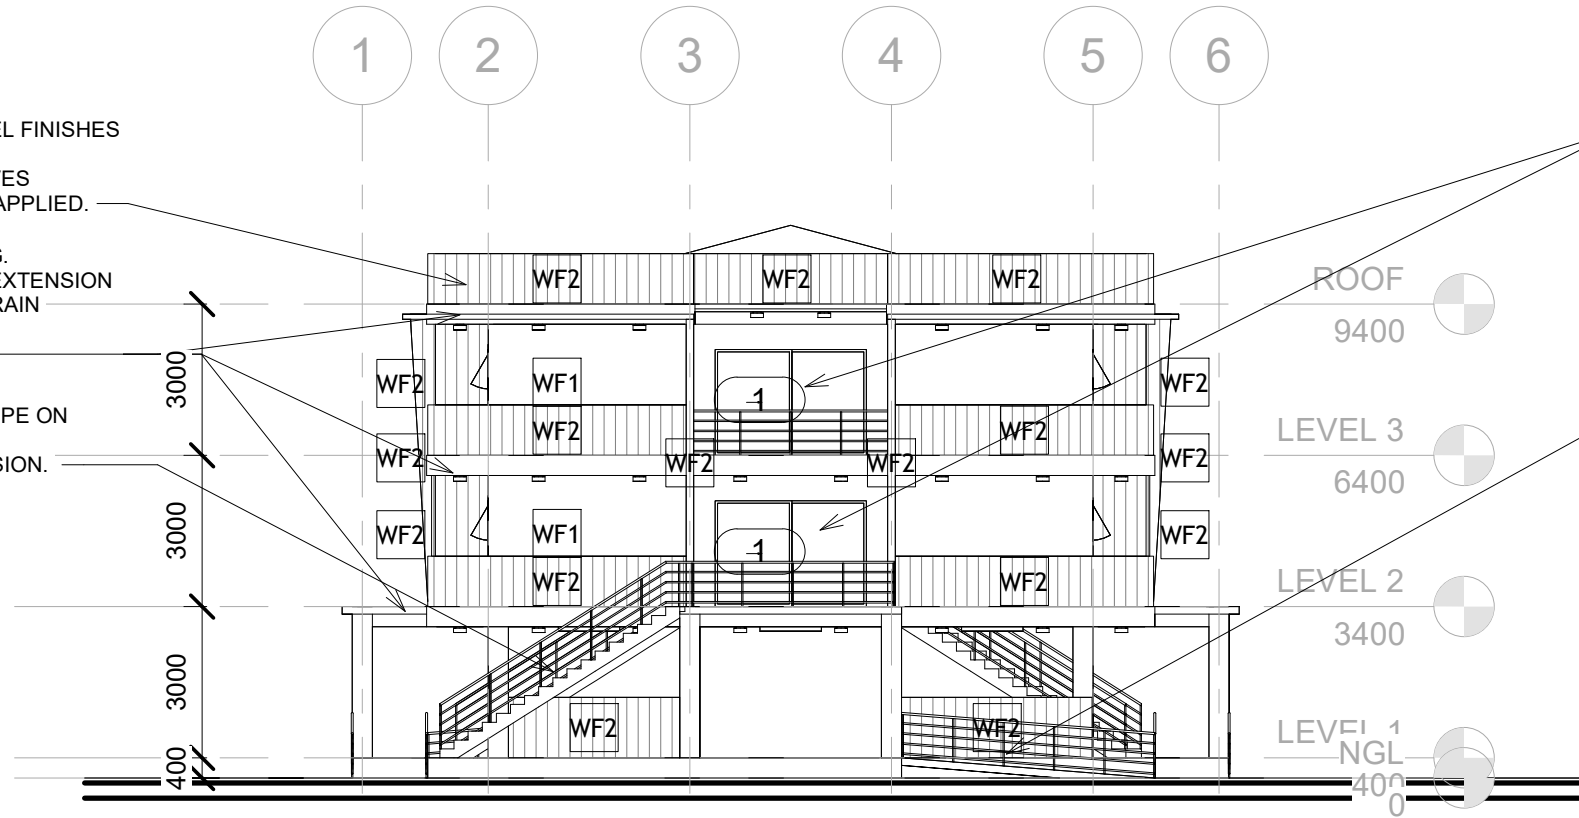

1 FRONT ELEVATION
1 : 150

J I H G F E D C B A

mm METAL RAILING FULLY
LDED PIPE PAINTED WITH EPOXY
MER TO PREVENT RUST AND
RROSION.



ROOF

9400

LEVEL 3

6400

LEVEL 2

3400

LEVEL 1


-NGL

400

RIGHT-SIDE ELEVATION

1

1 : 150

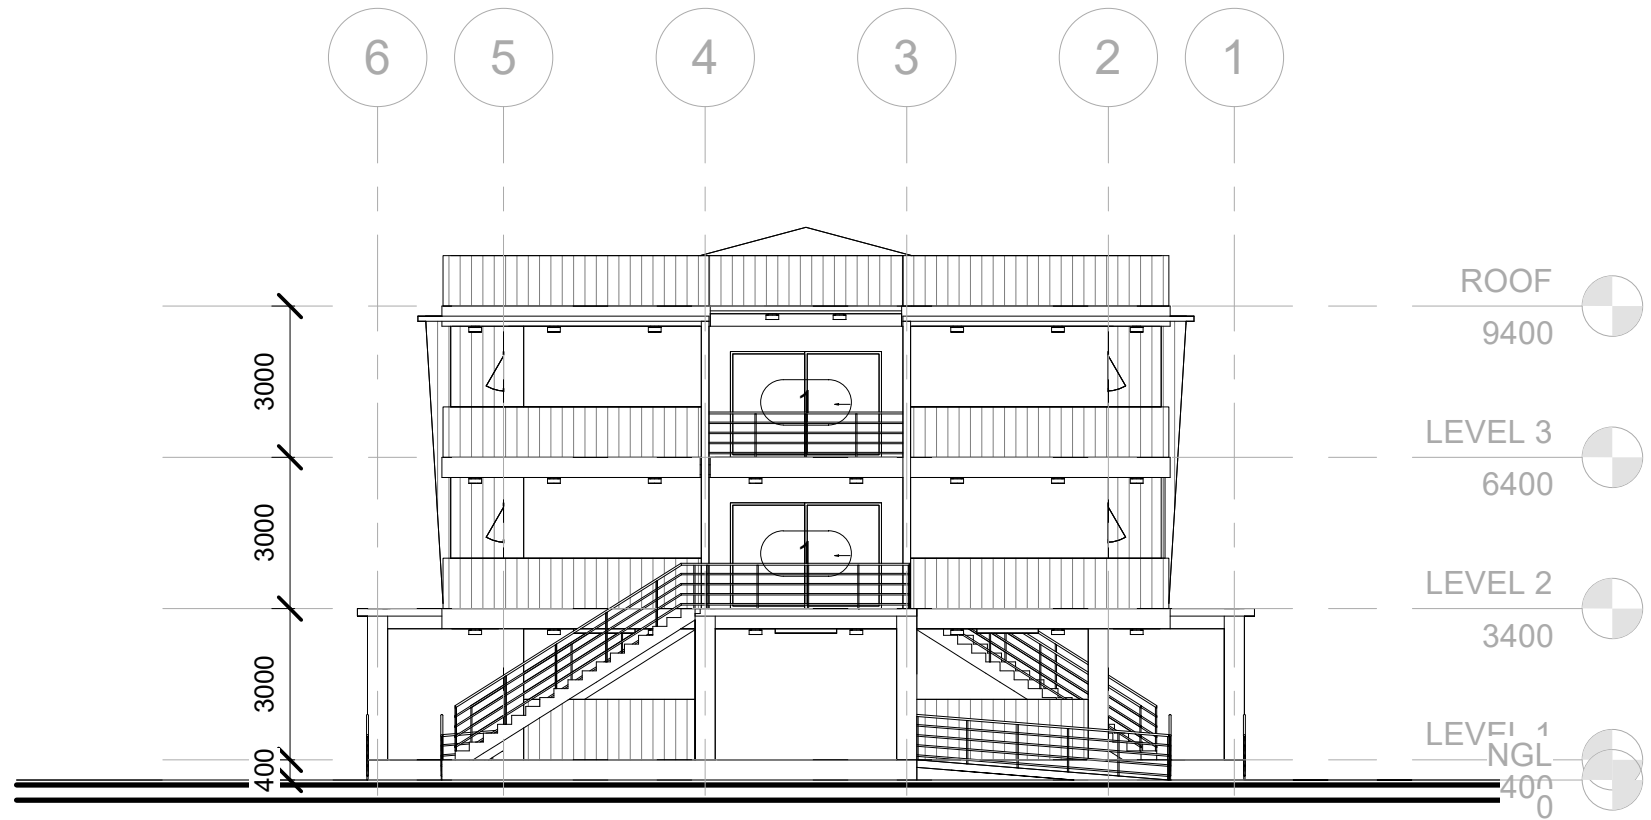

1 REAR ELEVATION
1 : 150


A B C D E F G H I J

400
3000
3000
3000




ROOF 9400
LEVEL 3 6400
LEVEL 2 3400
LEVEL 1 -NGL 400


1 LEFT-SIDE ELEVATION
1 : 150

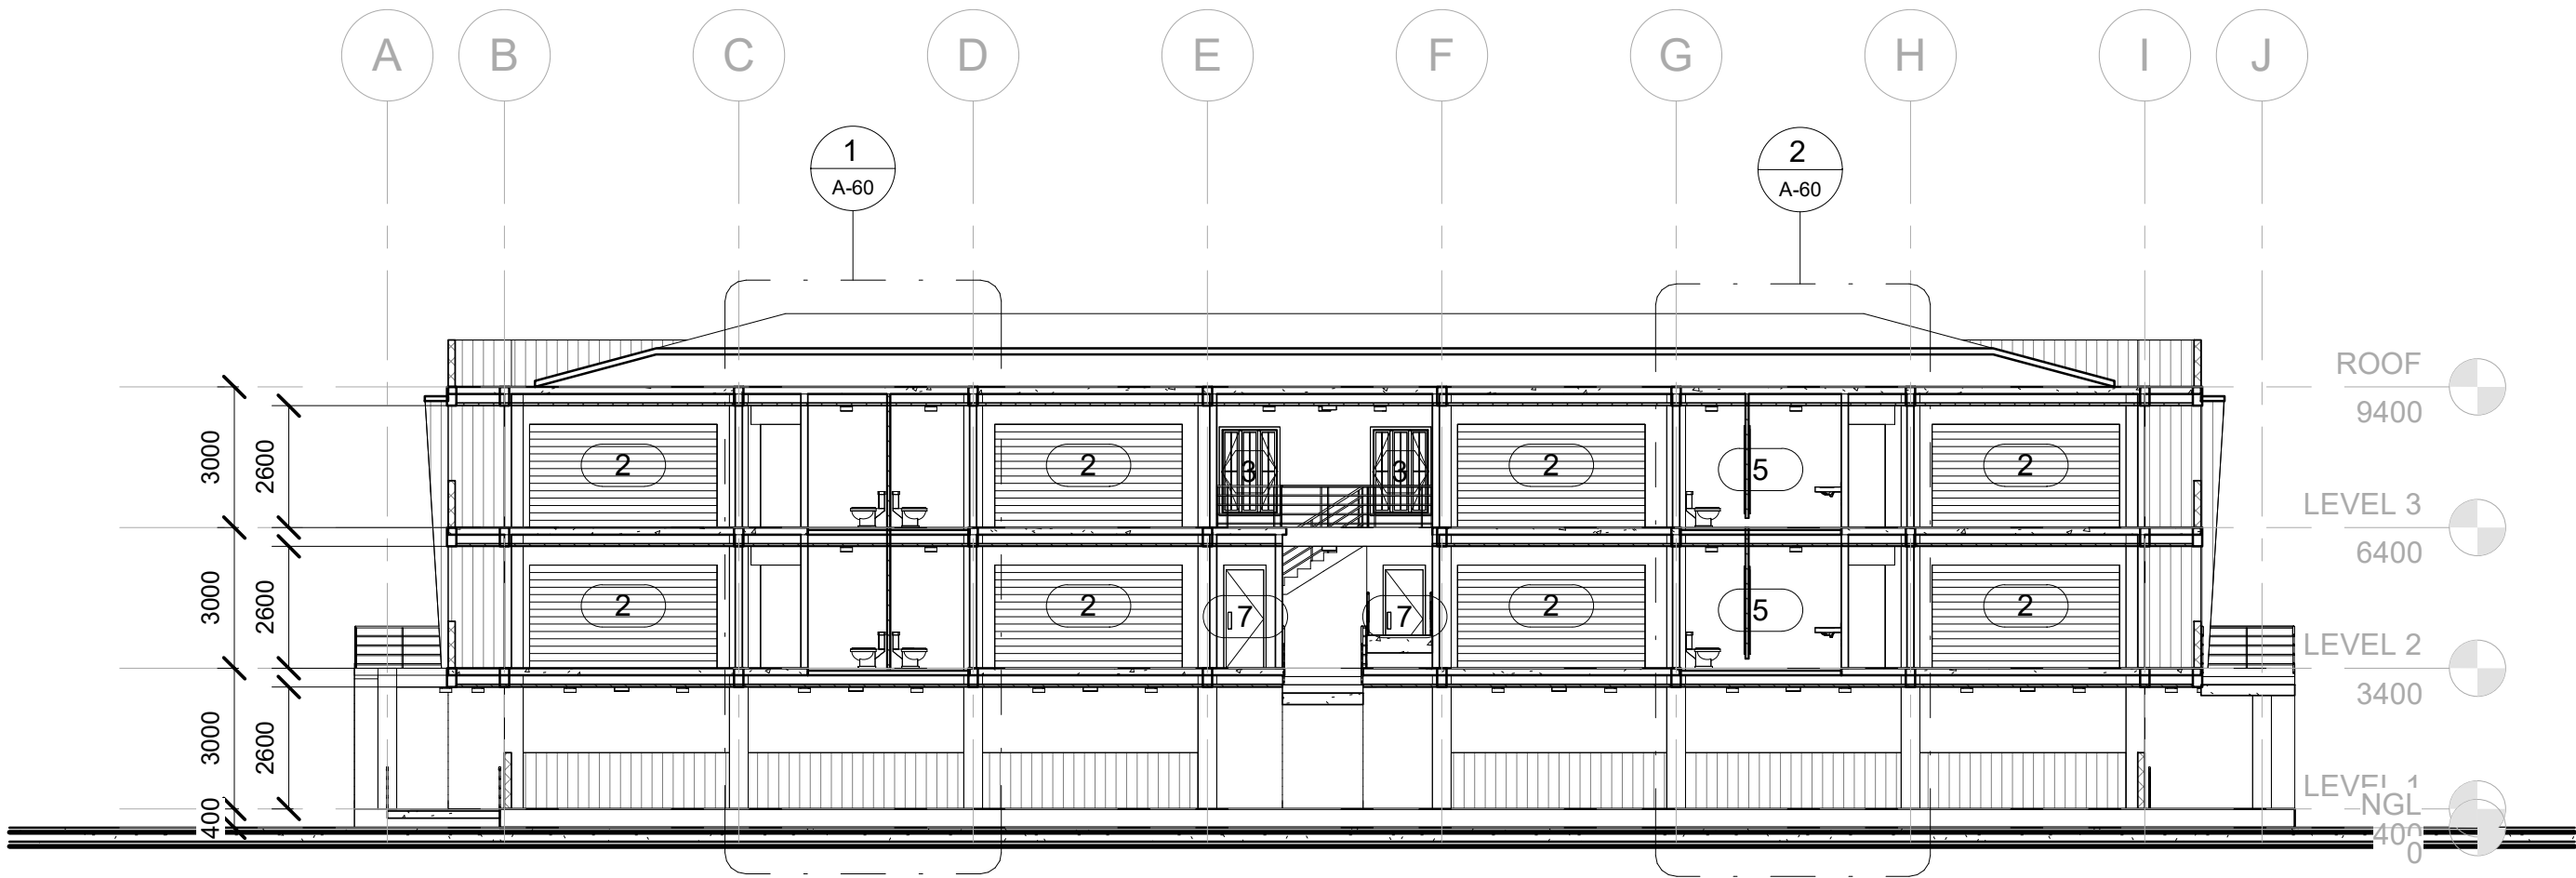



1
LONGITUDINAL SECTION
 1 : 150

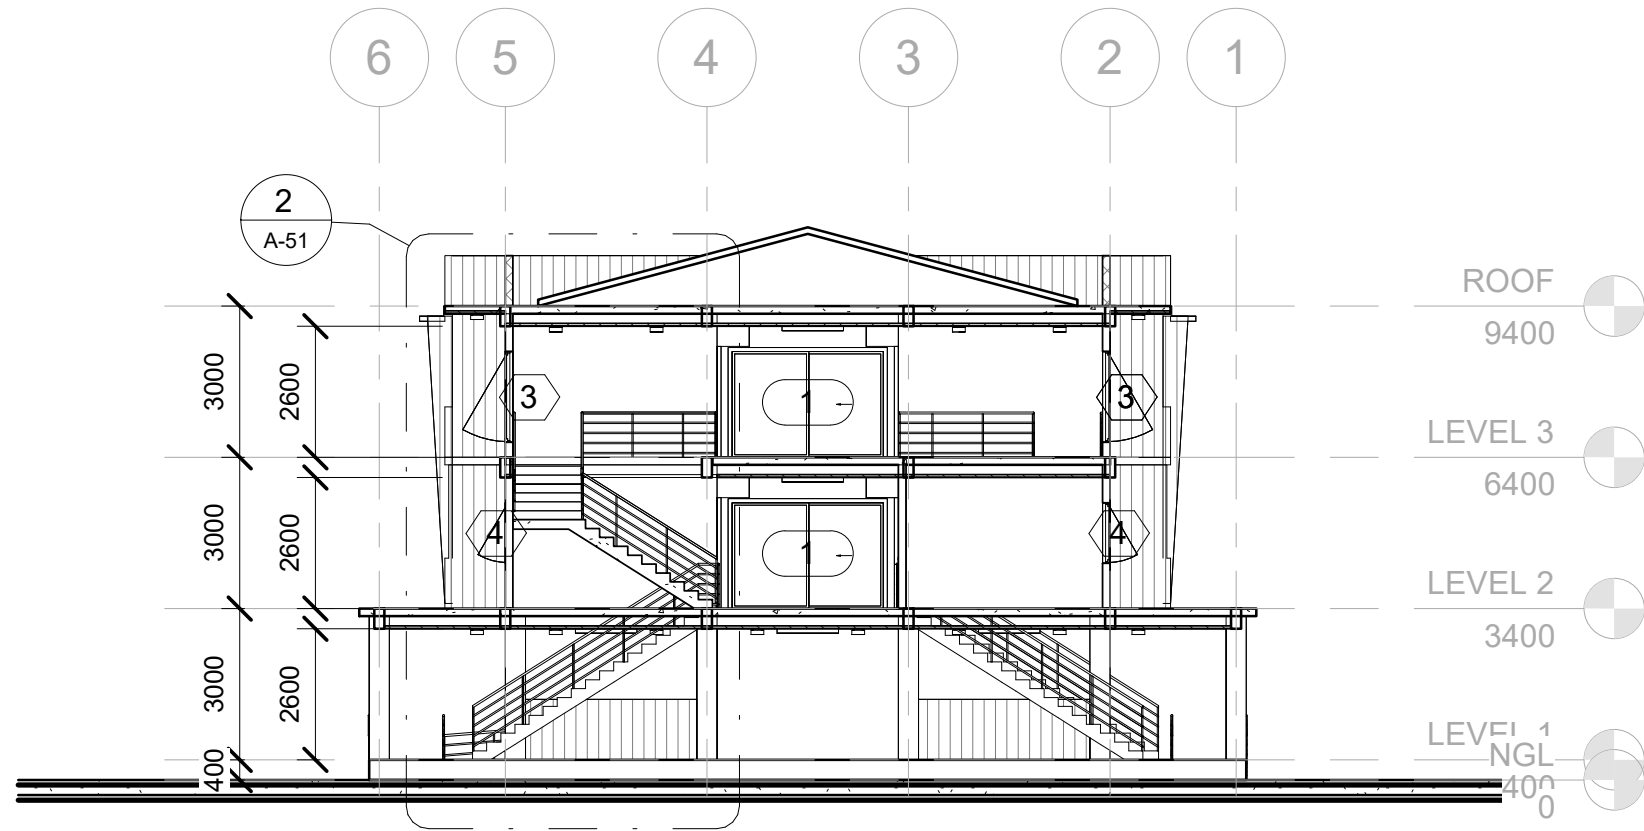

1 CROSS SECTION
1 : 150

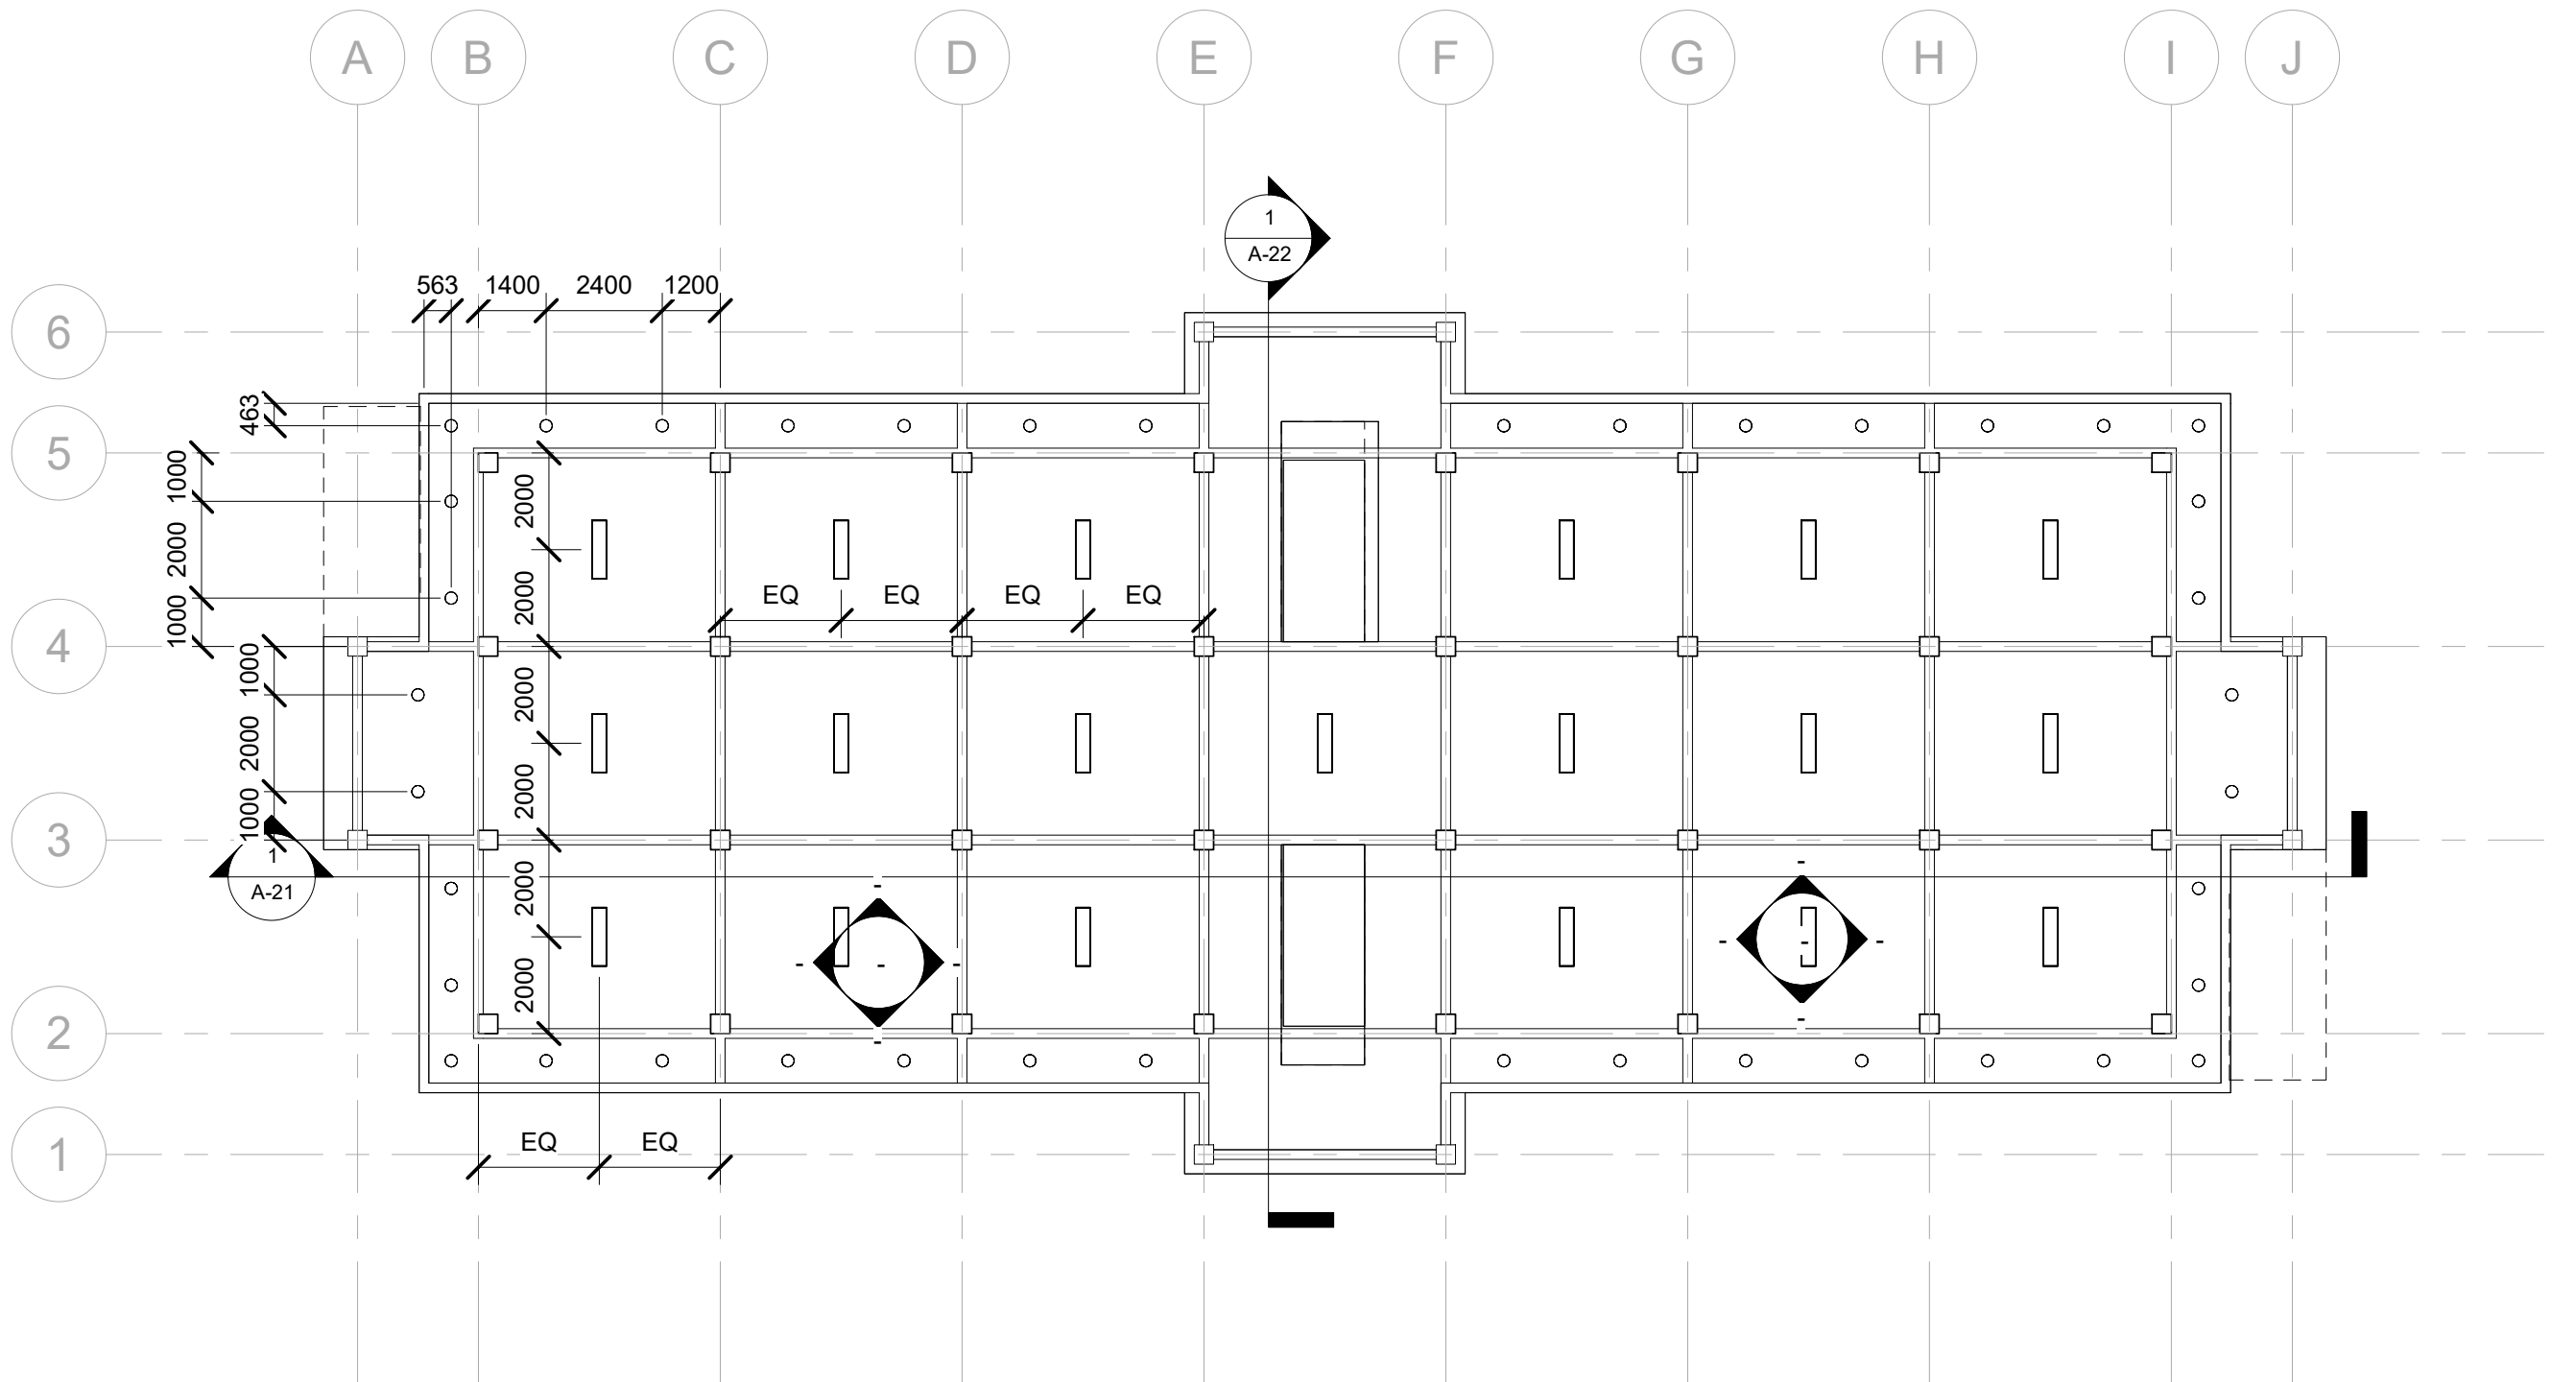

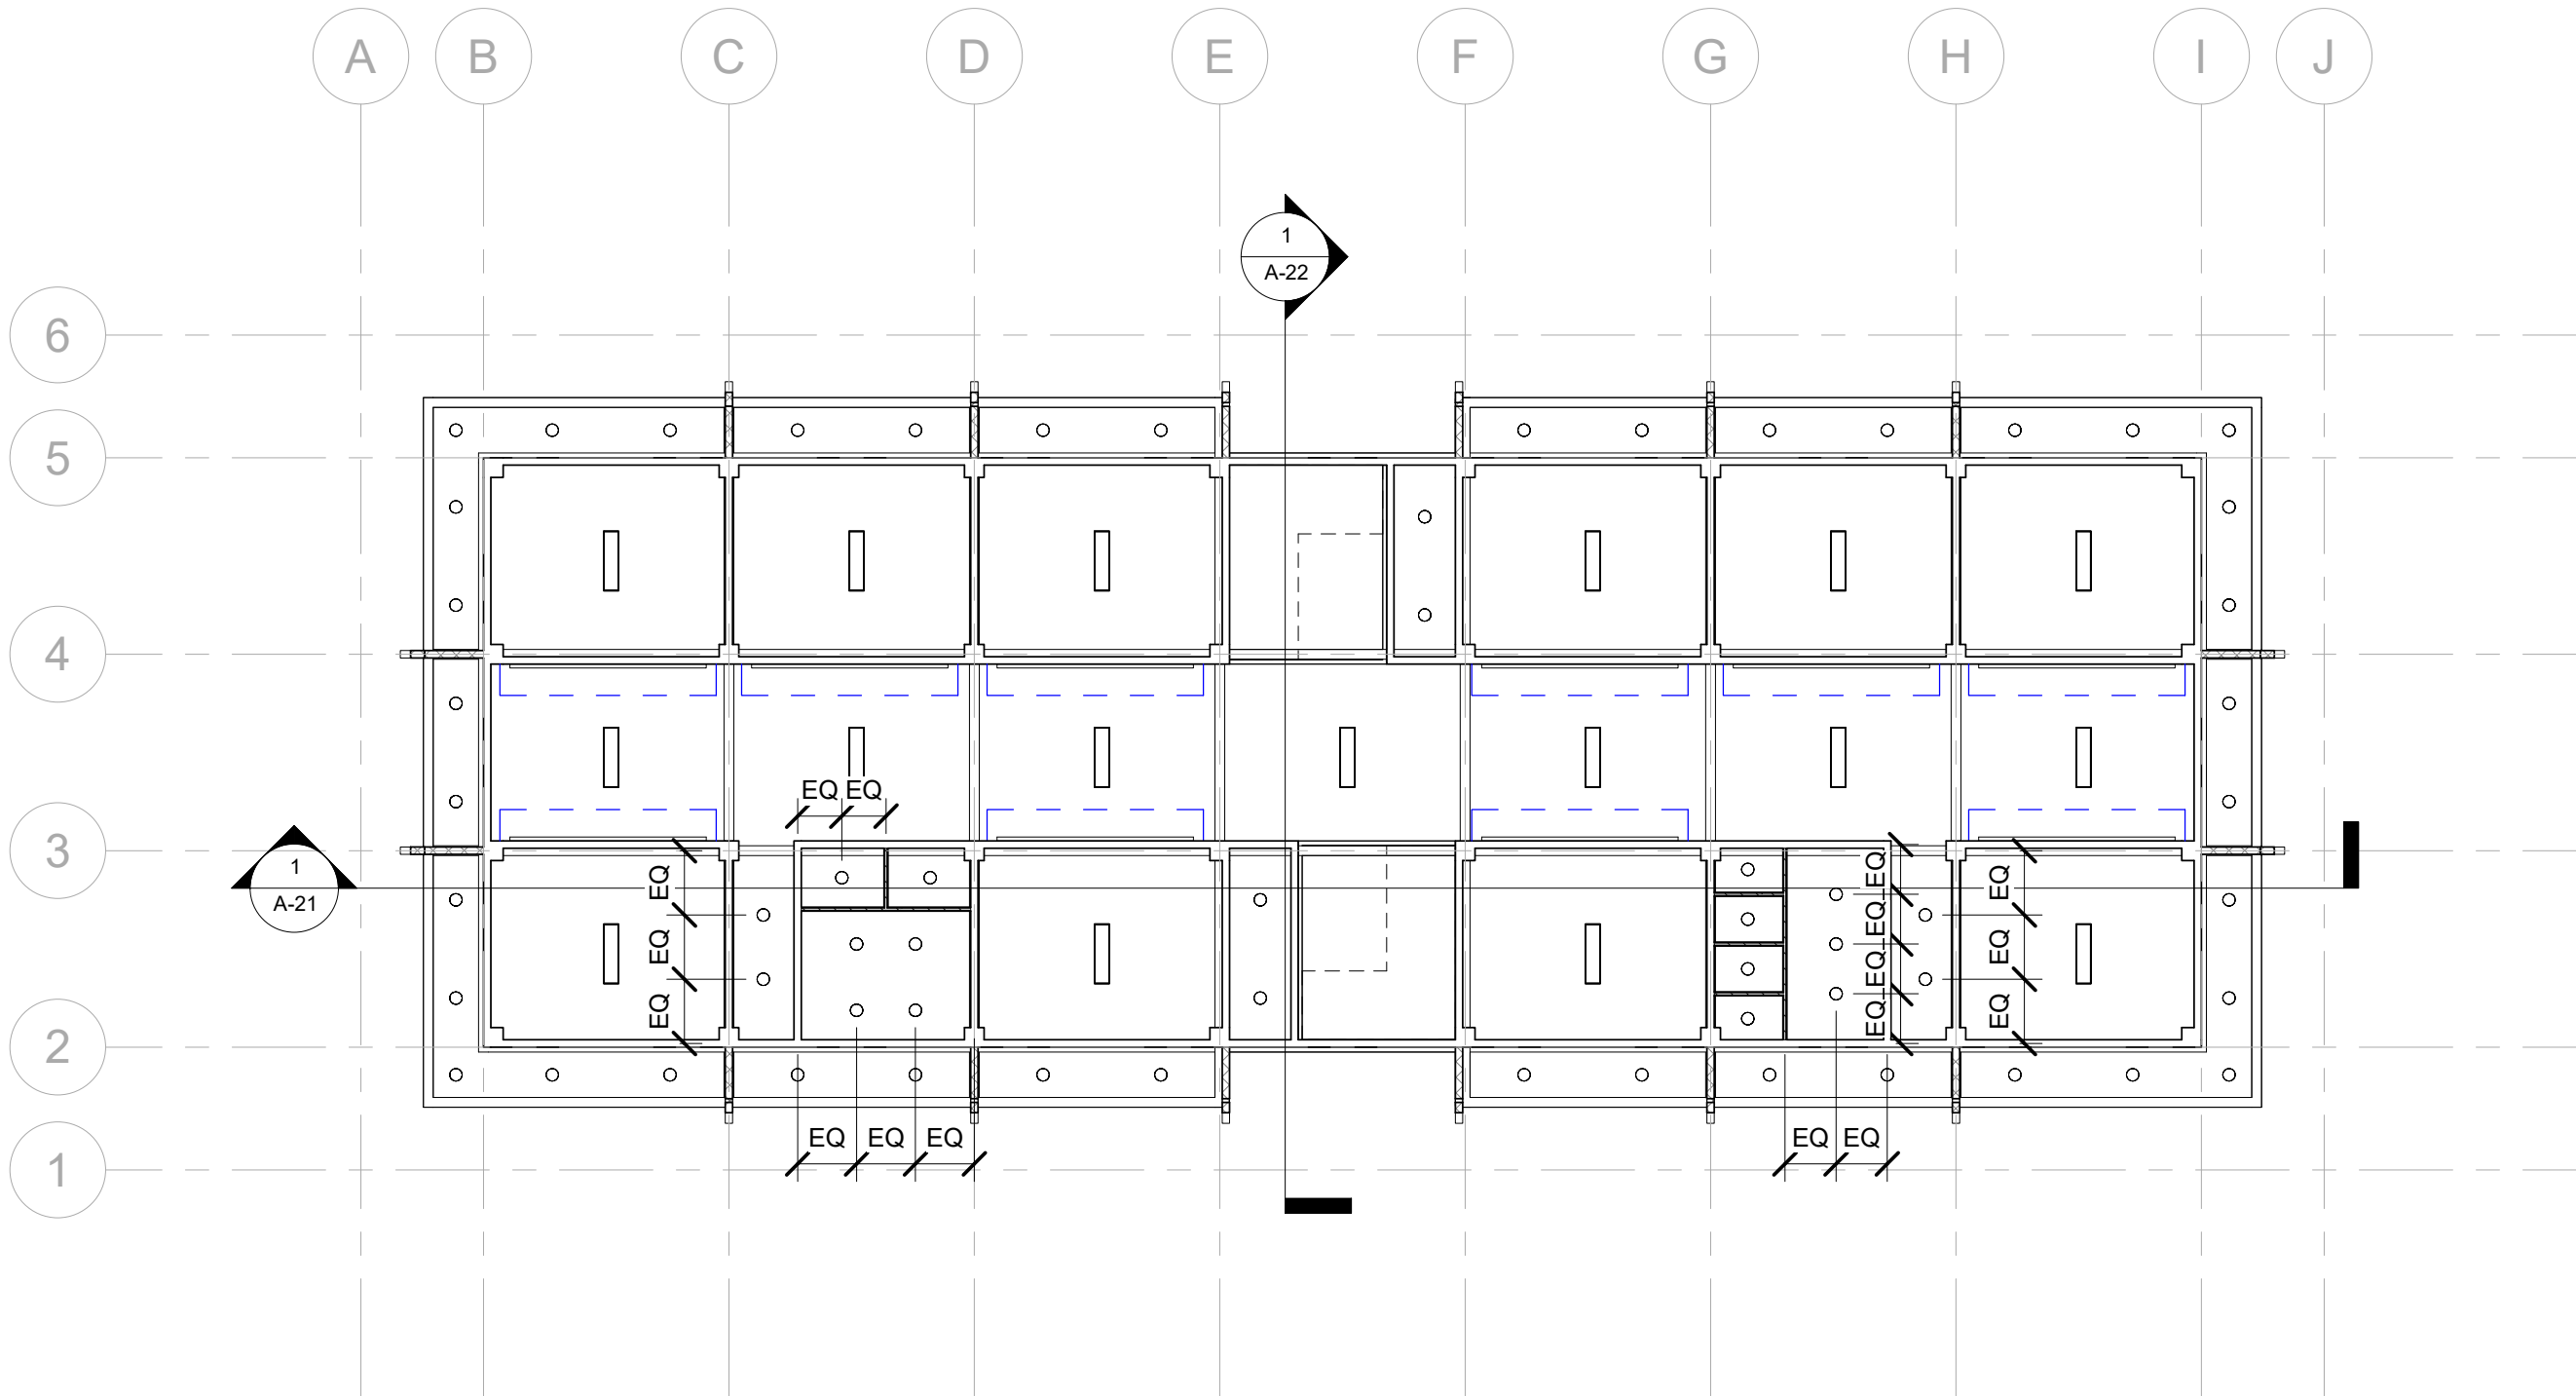


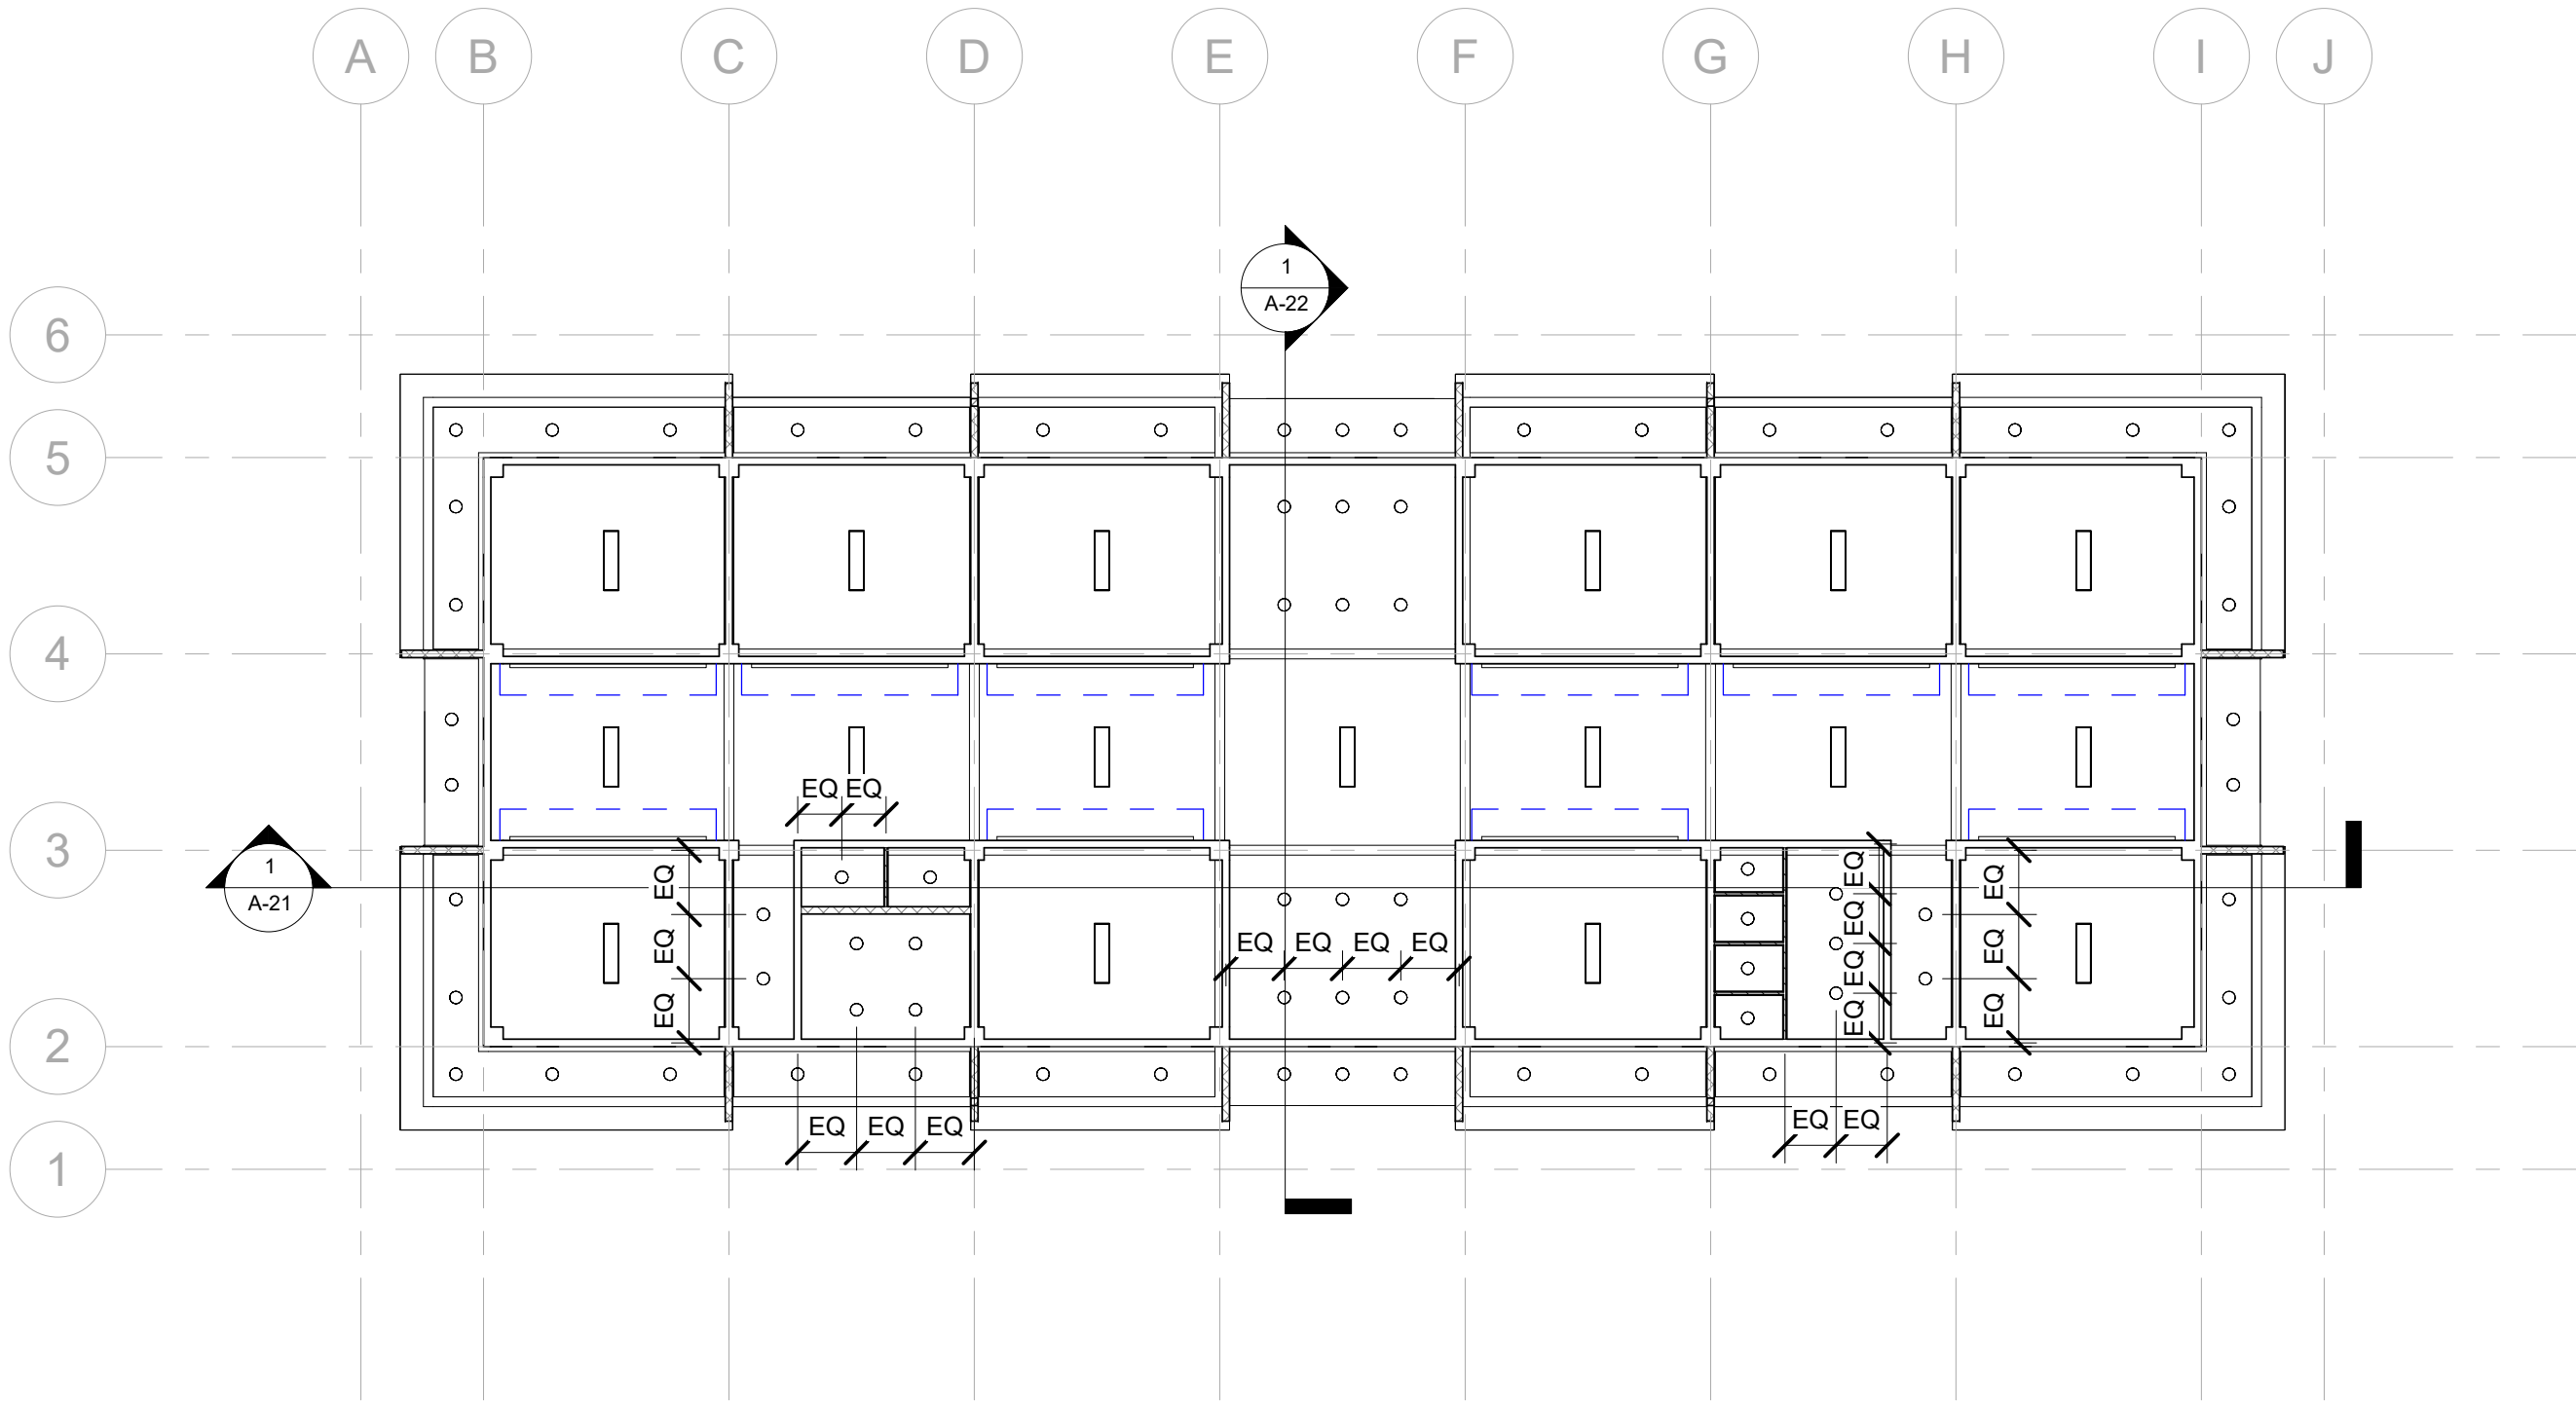


Door Quantities							
Assembly Description	Count	Door Description	Type	Width	Height	Thickness	Door Type
Interior Doors	4	M_Door-Double-Sliding	3000mm x 2100mm	3000	2100	50	1
Overhead Doors & Roll-up Grilles	20	M_Door-Overhead-Rolling	2400mm x 4000mm	4000	2200	80	2
Glazed Doors & Entrances	24	M_Door-Passage-Single-Two_Lite_Narrow	Door Passage - Single Swing 2 Lite Narrow	900	2100	45	3
	4	M_Single-Flush	800mm x 2100mm	800	2100	51	4
	12	M_Single-Flush	600mm x 2100mm	600	1800	51	5
Solid Exterior Doors	2	Door-Passage-Single-Flush-Dbf_Acting	STORE	800	2100	44	7
Grand total							

Window Quantities						
Count	Window Description	Type	Width	Height	Window Type	
	M_Window-Awning-Triple-Horizontal	1200 x 1200	1200	1200	4	
	M_Window-Awning-Triple-Horizontal	1800 x 500mm (W2-Toilet)	1800	500	2	
10	M_Window-Awning-Triple-Horizontal	1800 x 800mm (W1)	1800	800	1	
	M_Window-Awning-Triple-Horizontal	1800 x 1200	1200	1800	3	
Grand total						


Plumbing Fixture Quantities				
Count	Unit Description	Type	Description	Model
	M_Urinal with Wing - Wall Hung	Standard		
2	M_Water Closet - Flush Tank	Public - Flushing Greater than 6.1 Lpf		
	Plumbing-Sink-Sloan-Valve-DSCT-82000	DSCT-82000	Designer Series™ 2-Station Wall-Mounted Counter Top Sink.	DSCT-82000
	Plumbing-Sink-Sloan-Valve-DSCT-83000	DSCT-83000	Designer Series™ 3-Station Wall-Mounted Counter Top Sink.	DSCT-83000
Grand total				

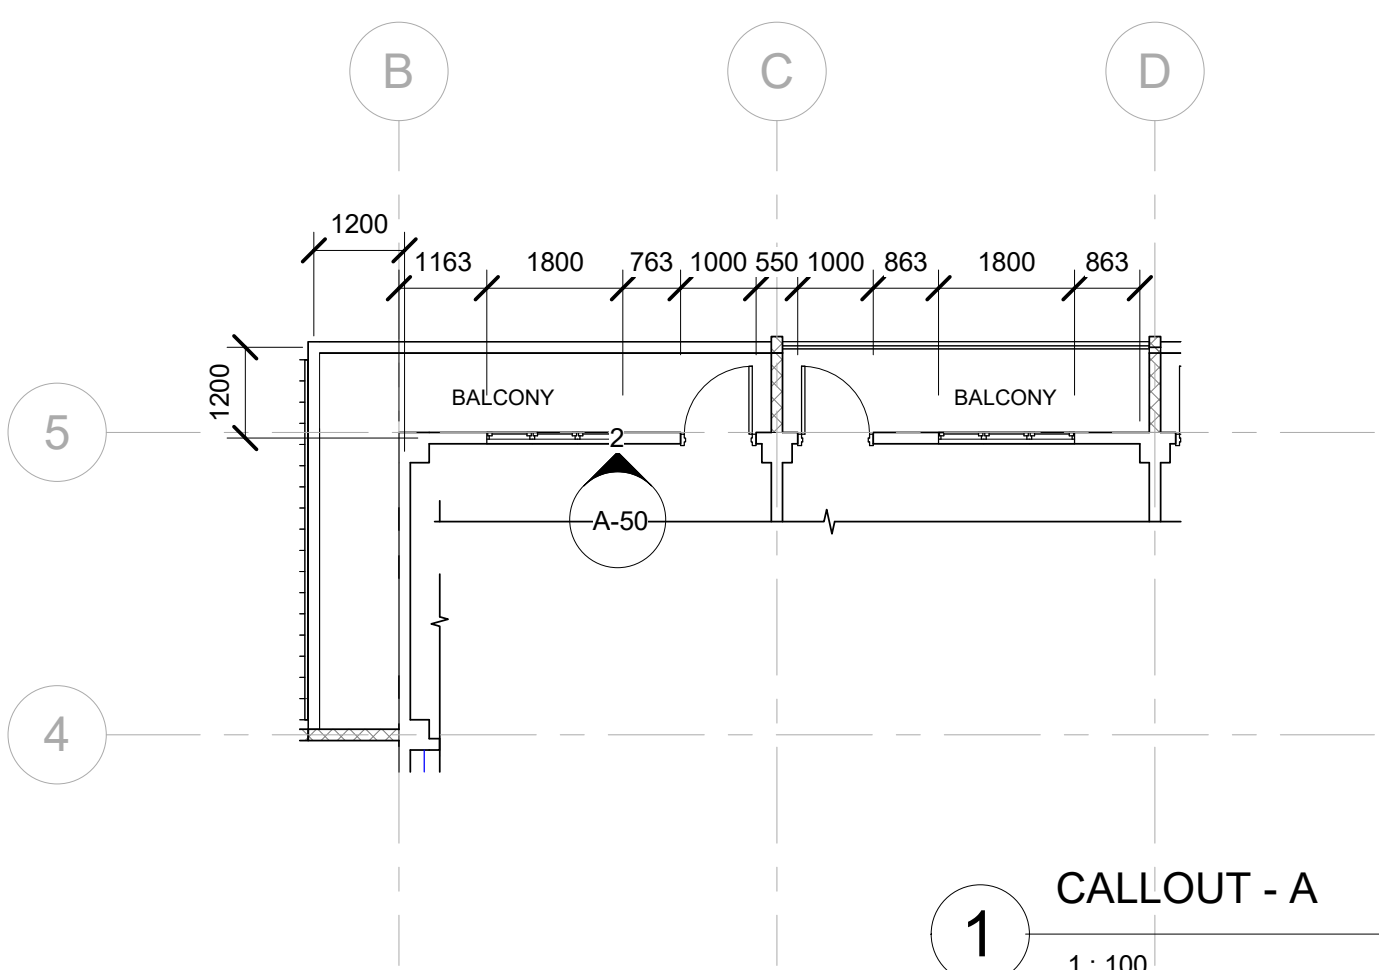

1 CALLOUT - A
1 : 100

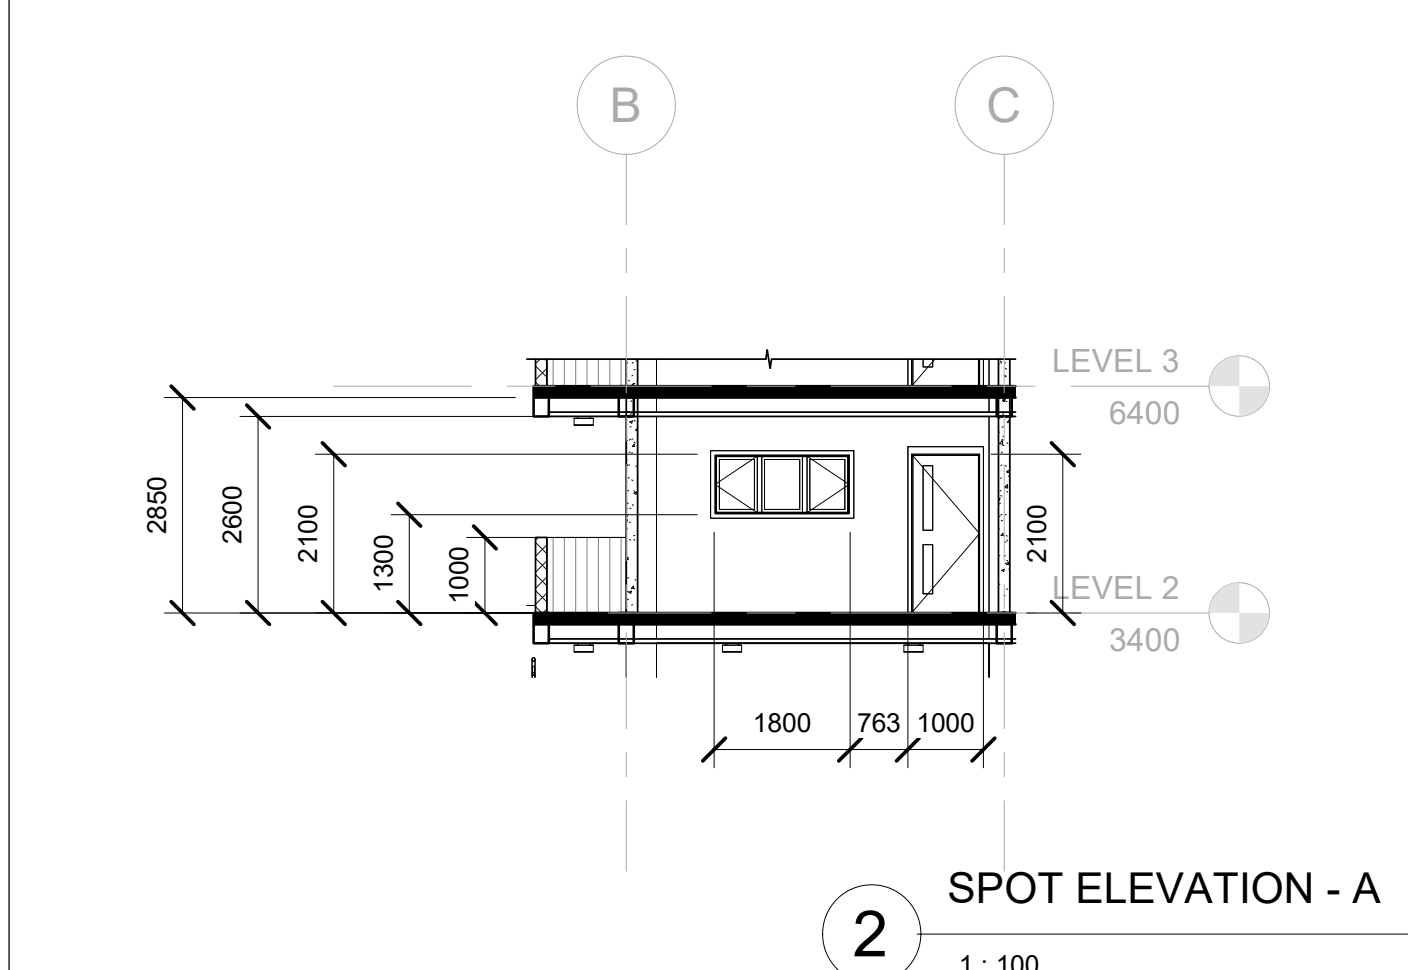


2 SPOT ELEVATION - A
1 : 100

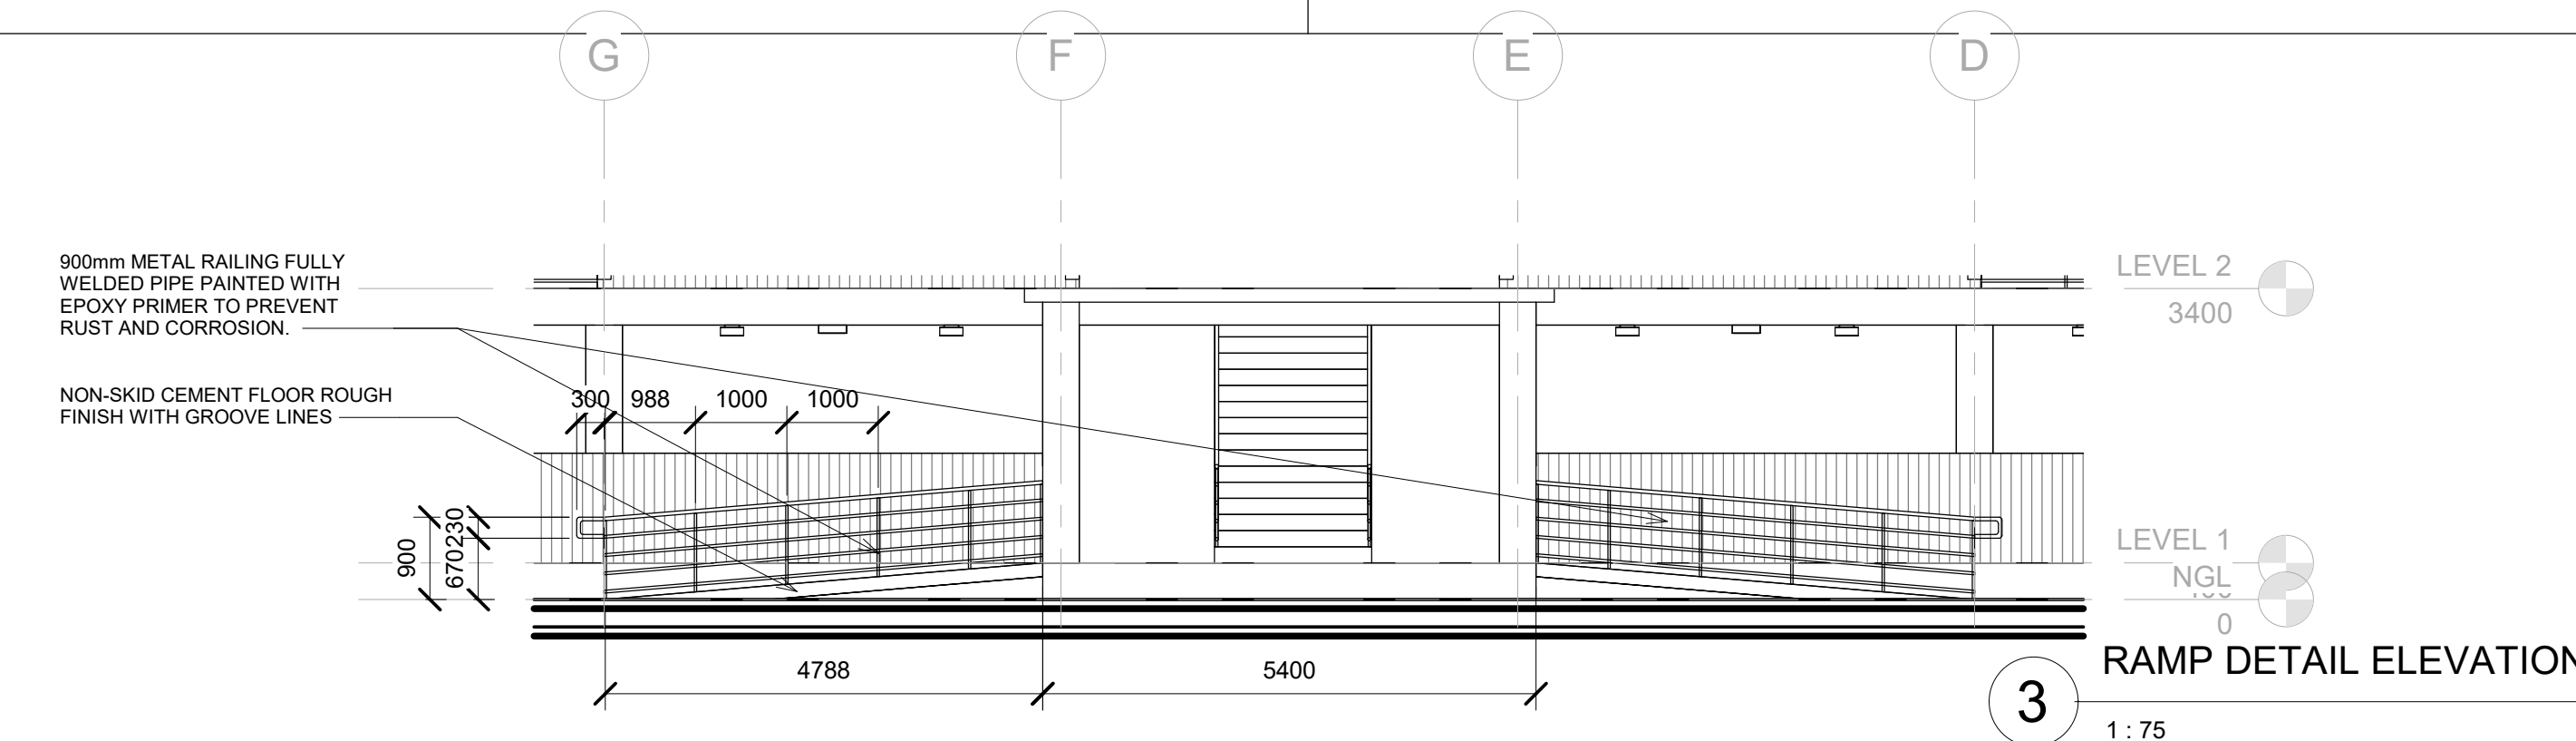

900mm METAL RAILING FULLY WELDED PIPE PAINTED WITH EPOXY PRIMER TO PREVENT RUST AND CORROSION.

NON-SKID CEMENT FLOOR ROUGH FINISH WITH GROOVE LINES

3 RAMP DETAIL ELEVATION
1 : 75

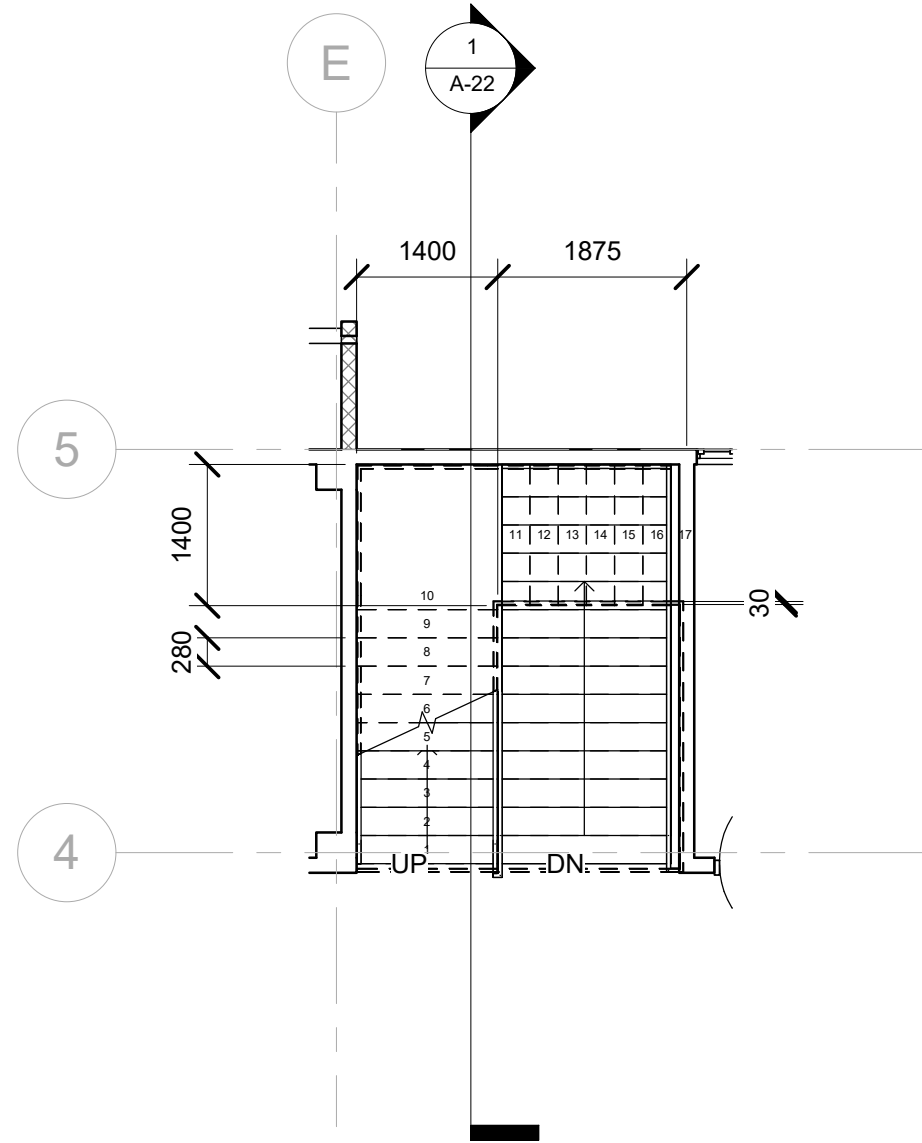

1


STAIRS PLAN

1:75

900mm METAL RAILING
FULLY WELDED PIPE
PAINTED WITH EPOXY
PRIMER TO PREVENT
RUST AND CORROSION.

LANDING


4.5mm THK. FIBER CEMENT
CEILING BOARD (PAINTED)
ON METAL FURRING @ 400mm
O.C.

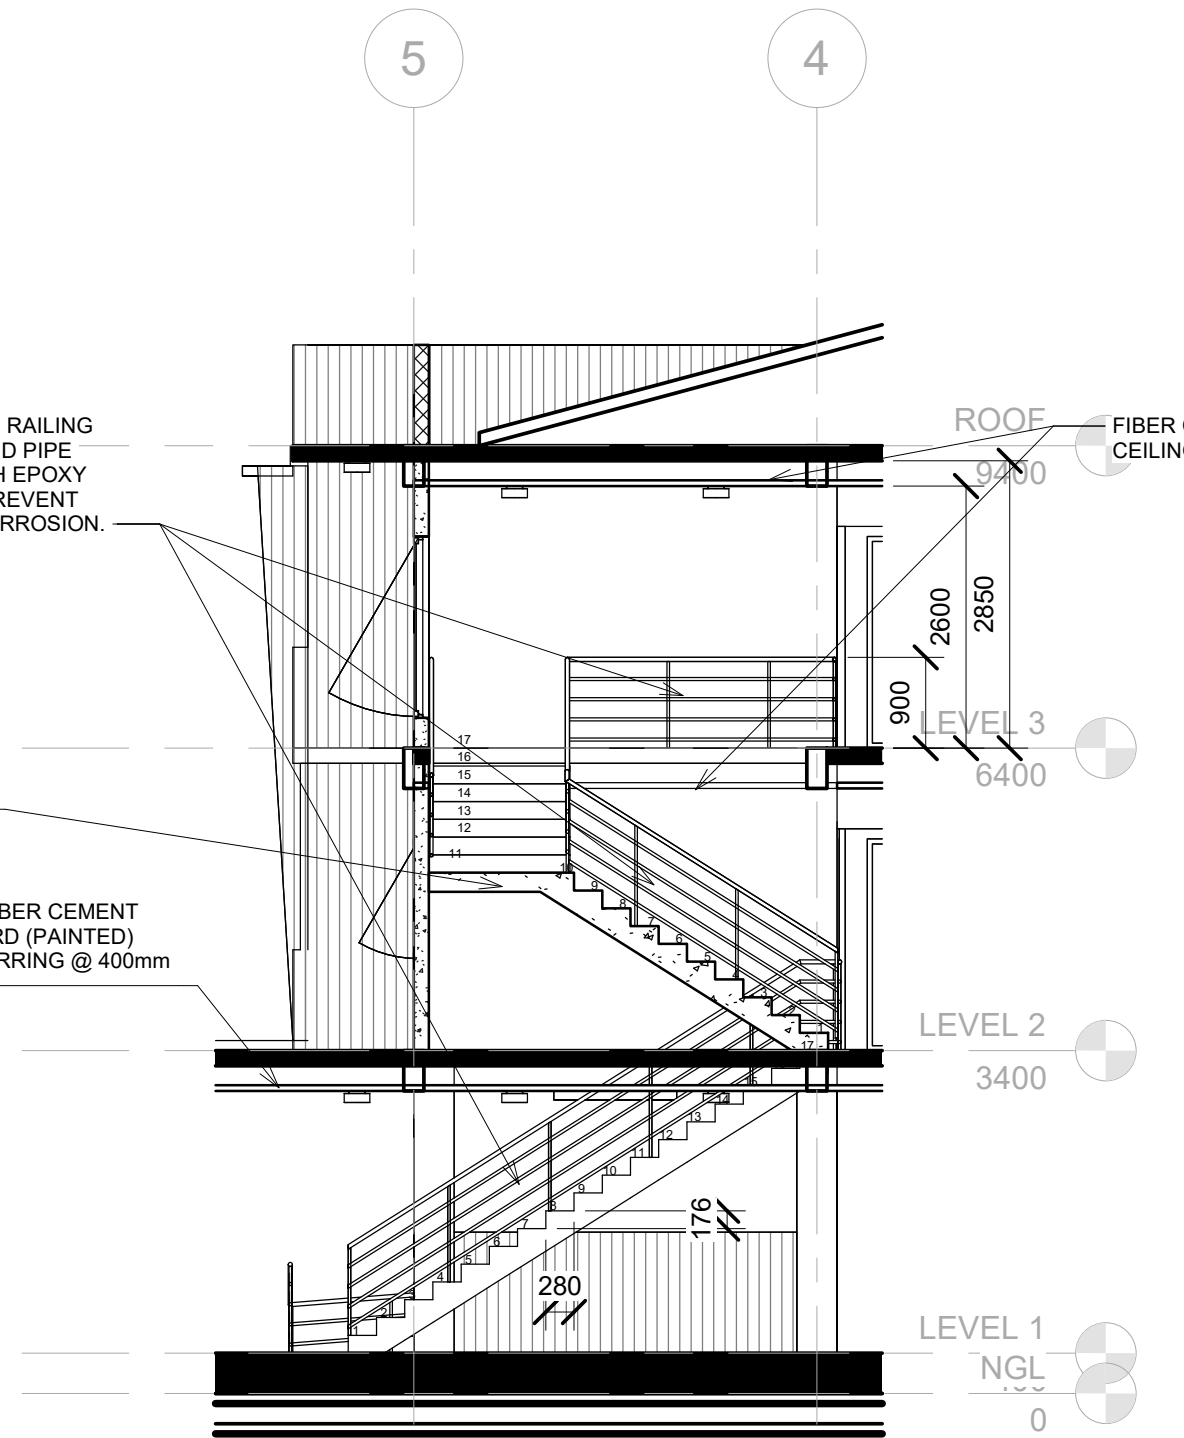

2

DETAIL SECTION OF STAIRS

1:75

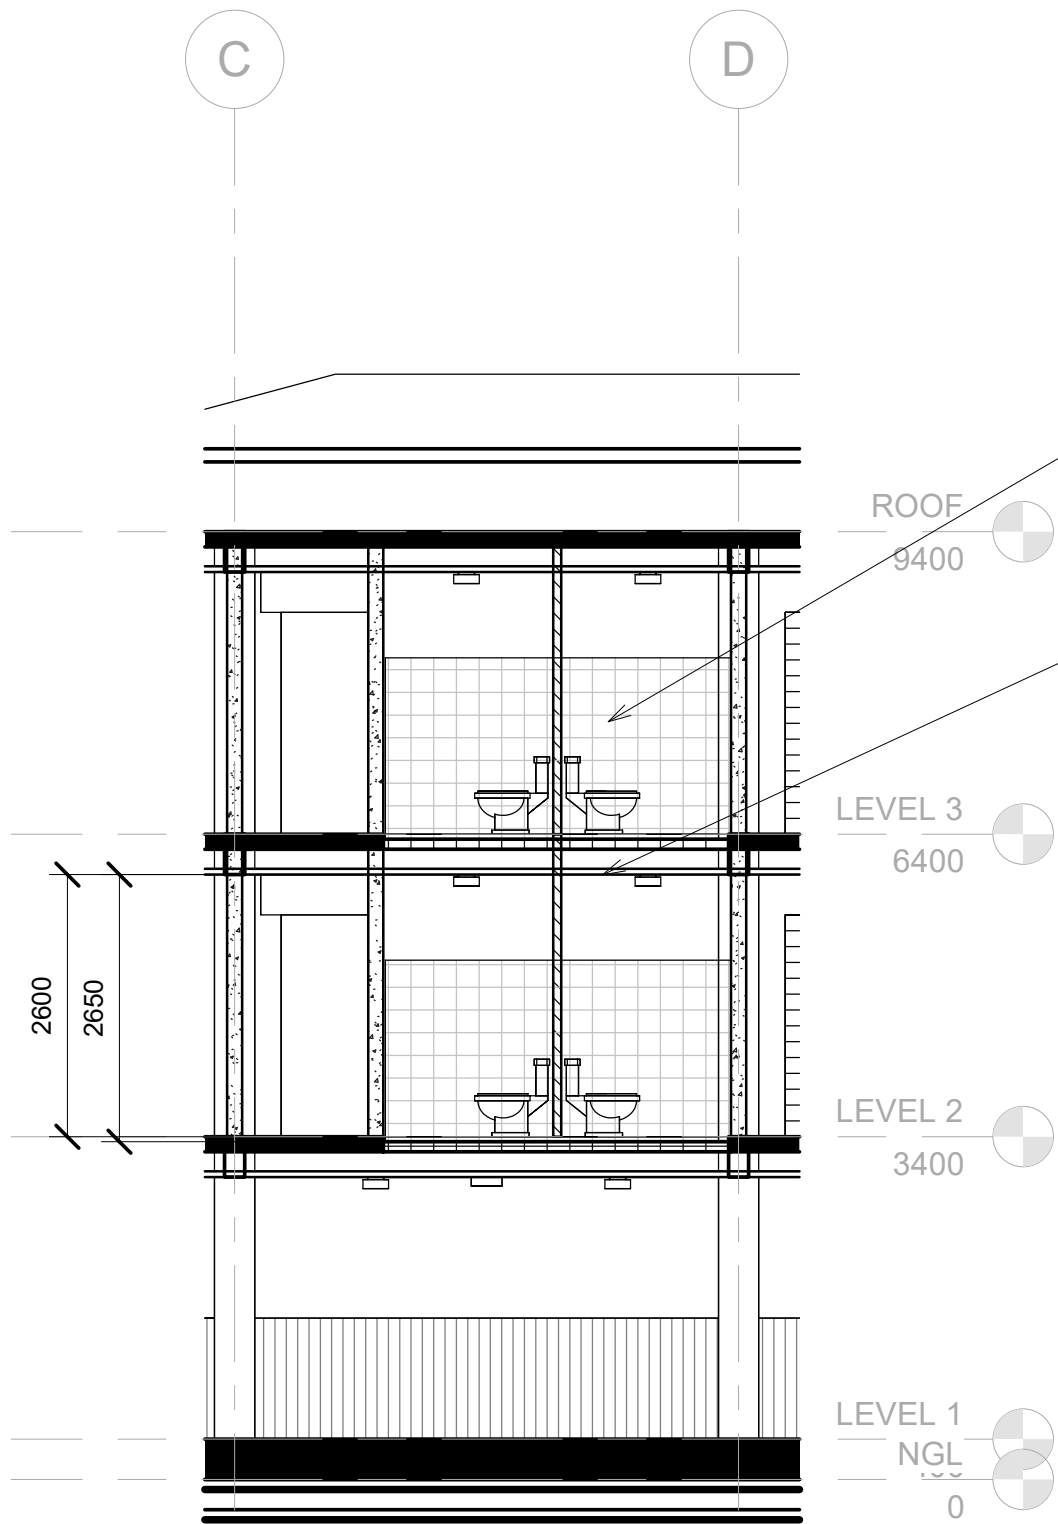

VITRIFIED 200mm x 200mm
TILES GLAZED FOR WALLS

MOISTURE RESISTANT CEILING
GYPSUM BOARD

ROOF

9400

LEVEL 3

6400


LEVEL 2

3400

LEVEL 1

NGL

0

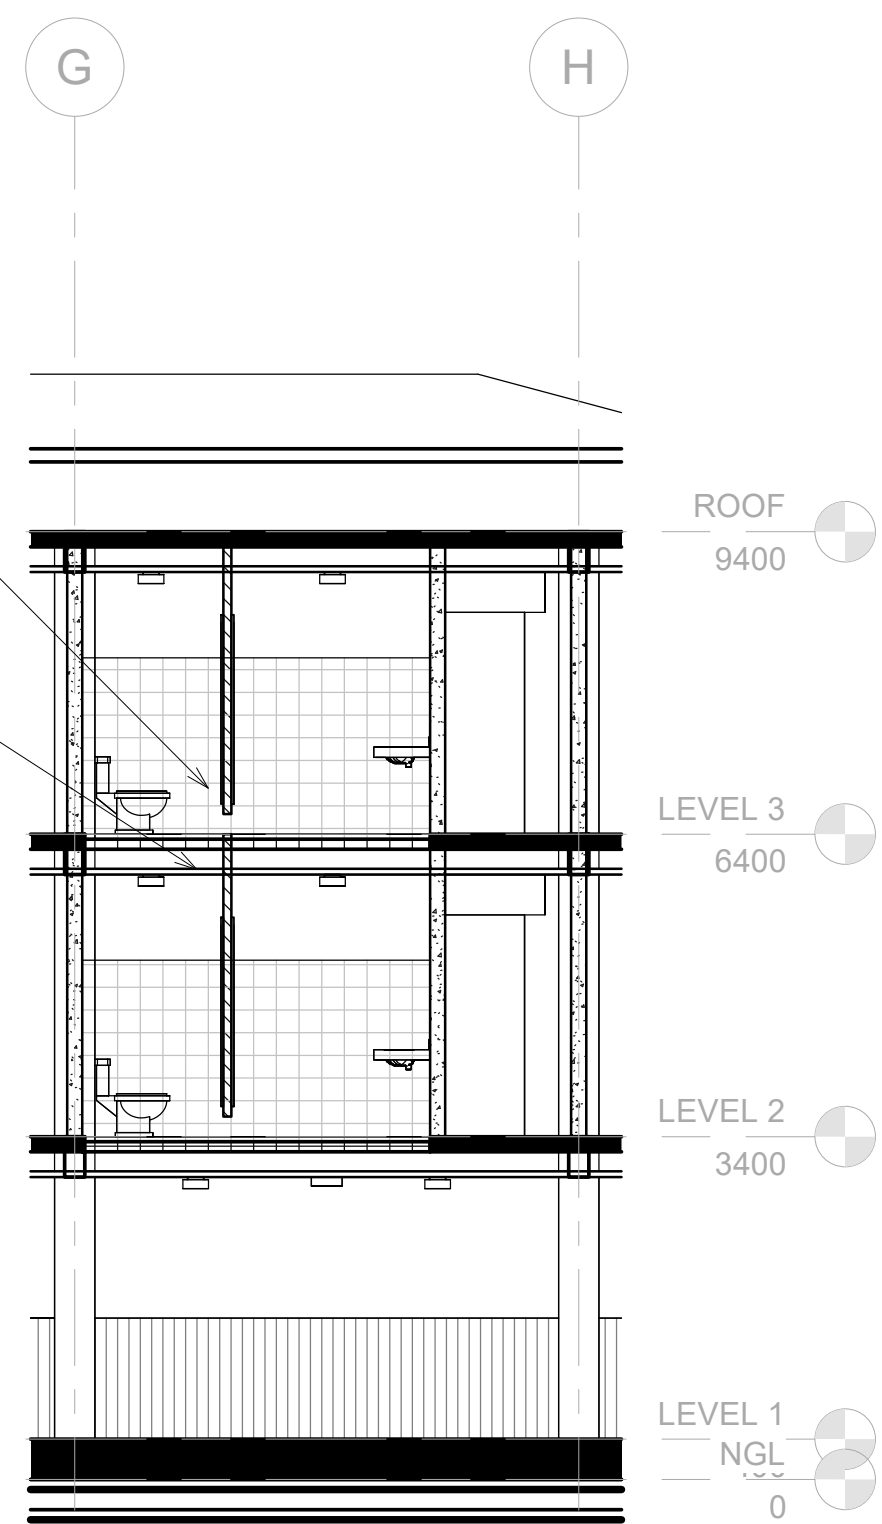

ROOF

9400

LEVEL 3

6400

LEVEL 2

3400


LEVEL 1

NGL

0


1 DETAIL ALONG MALE CR
1:75

2 DETAIL ALONG FEMALE CR
1:75

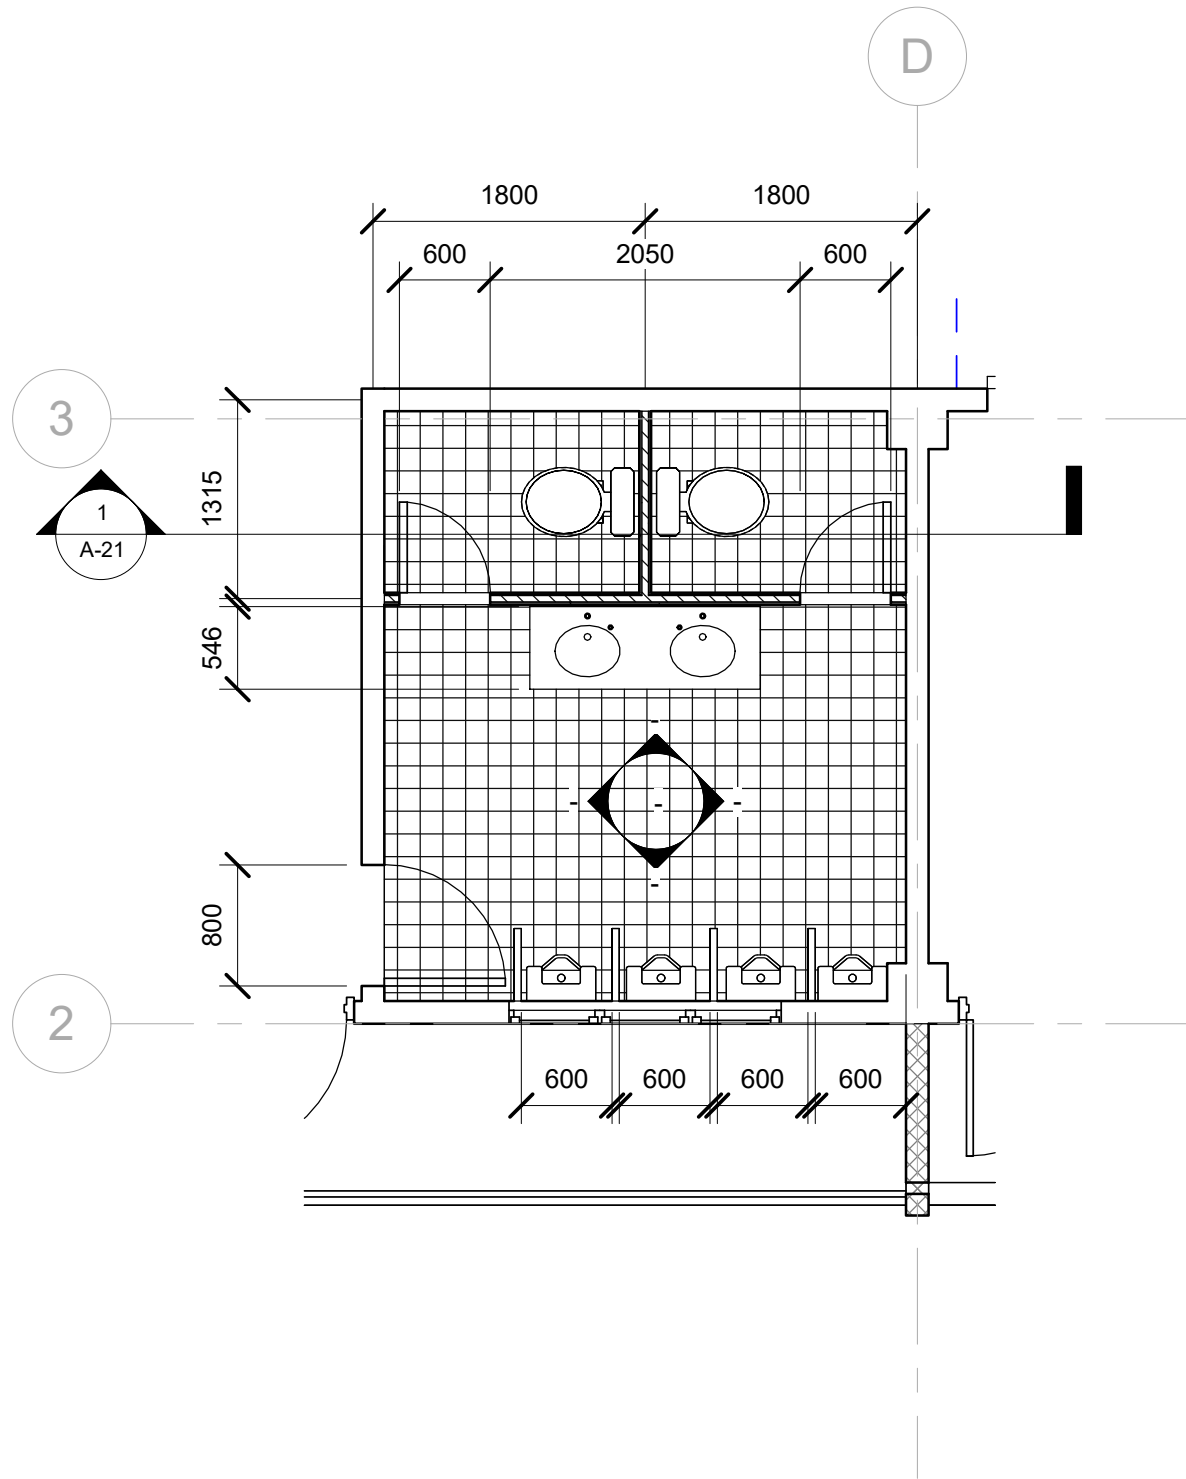

1 MALE CR PLAN

1 : 50

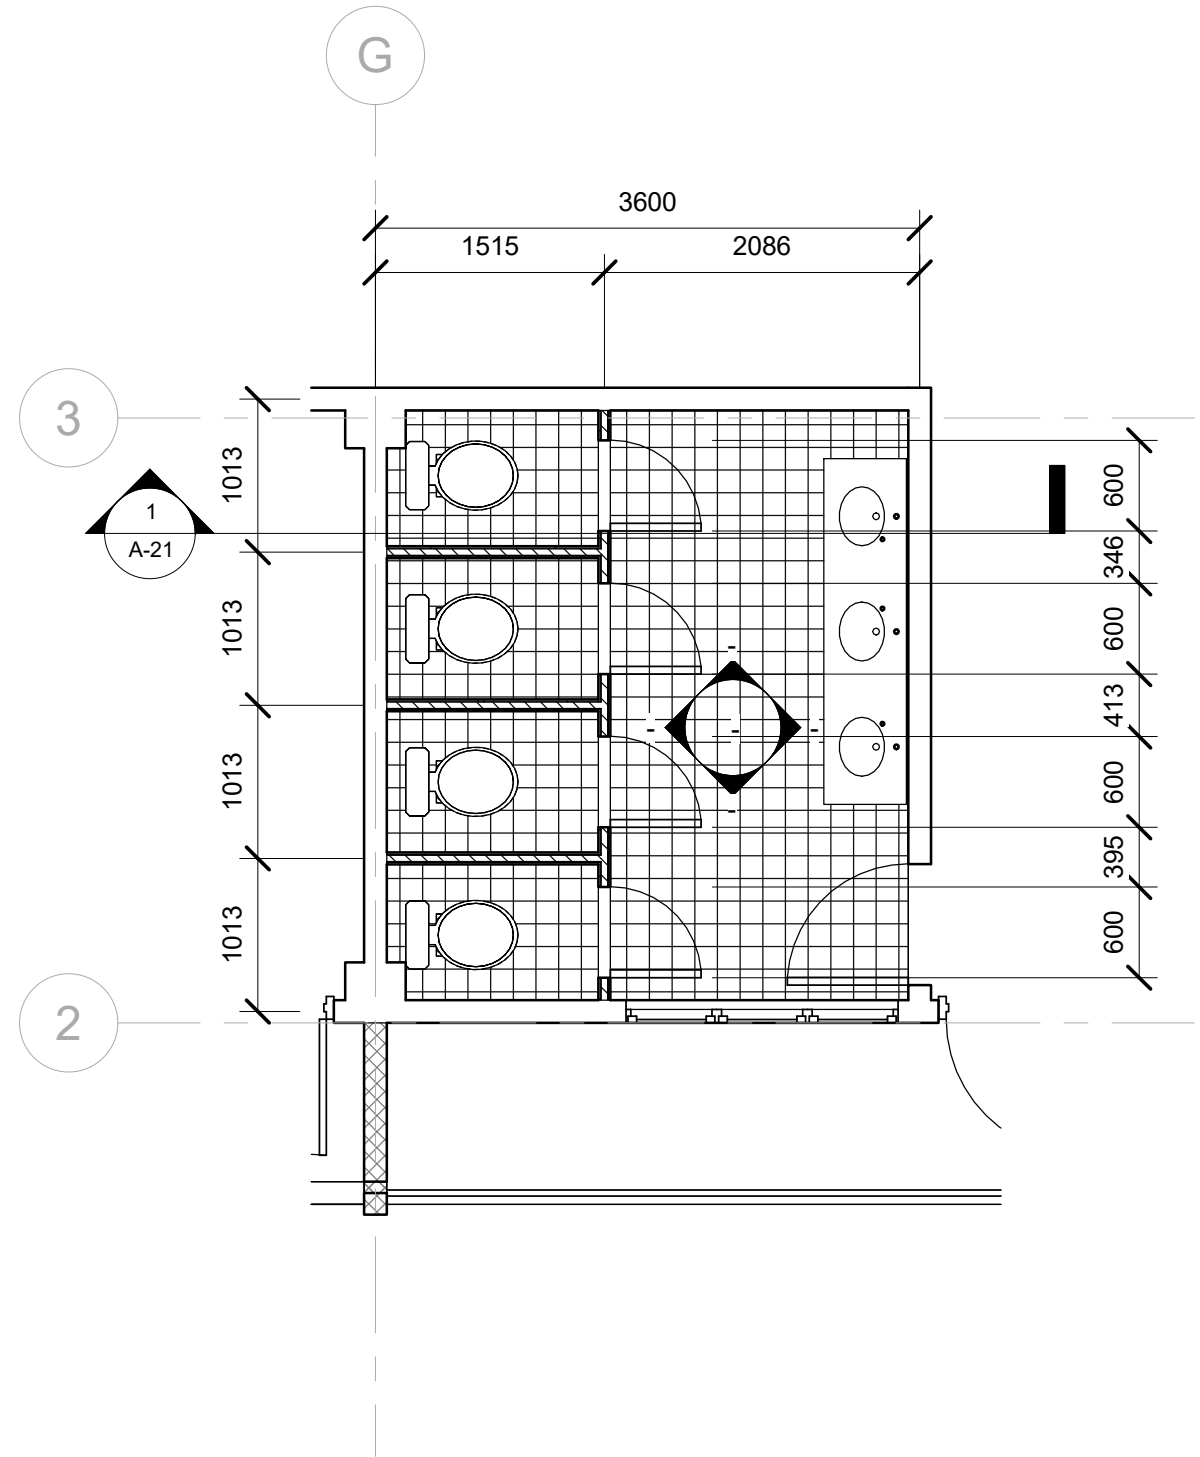

2 FEMALE CR PLANS

1 : 50



